


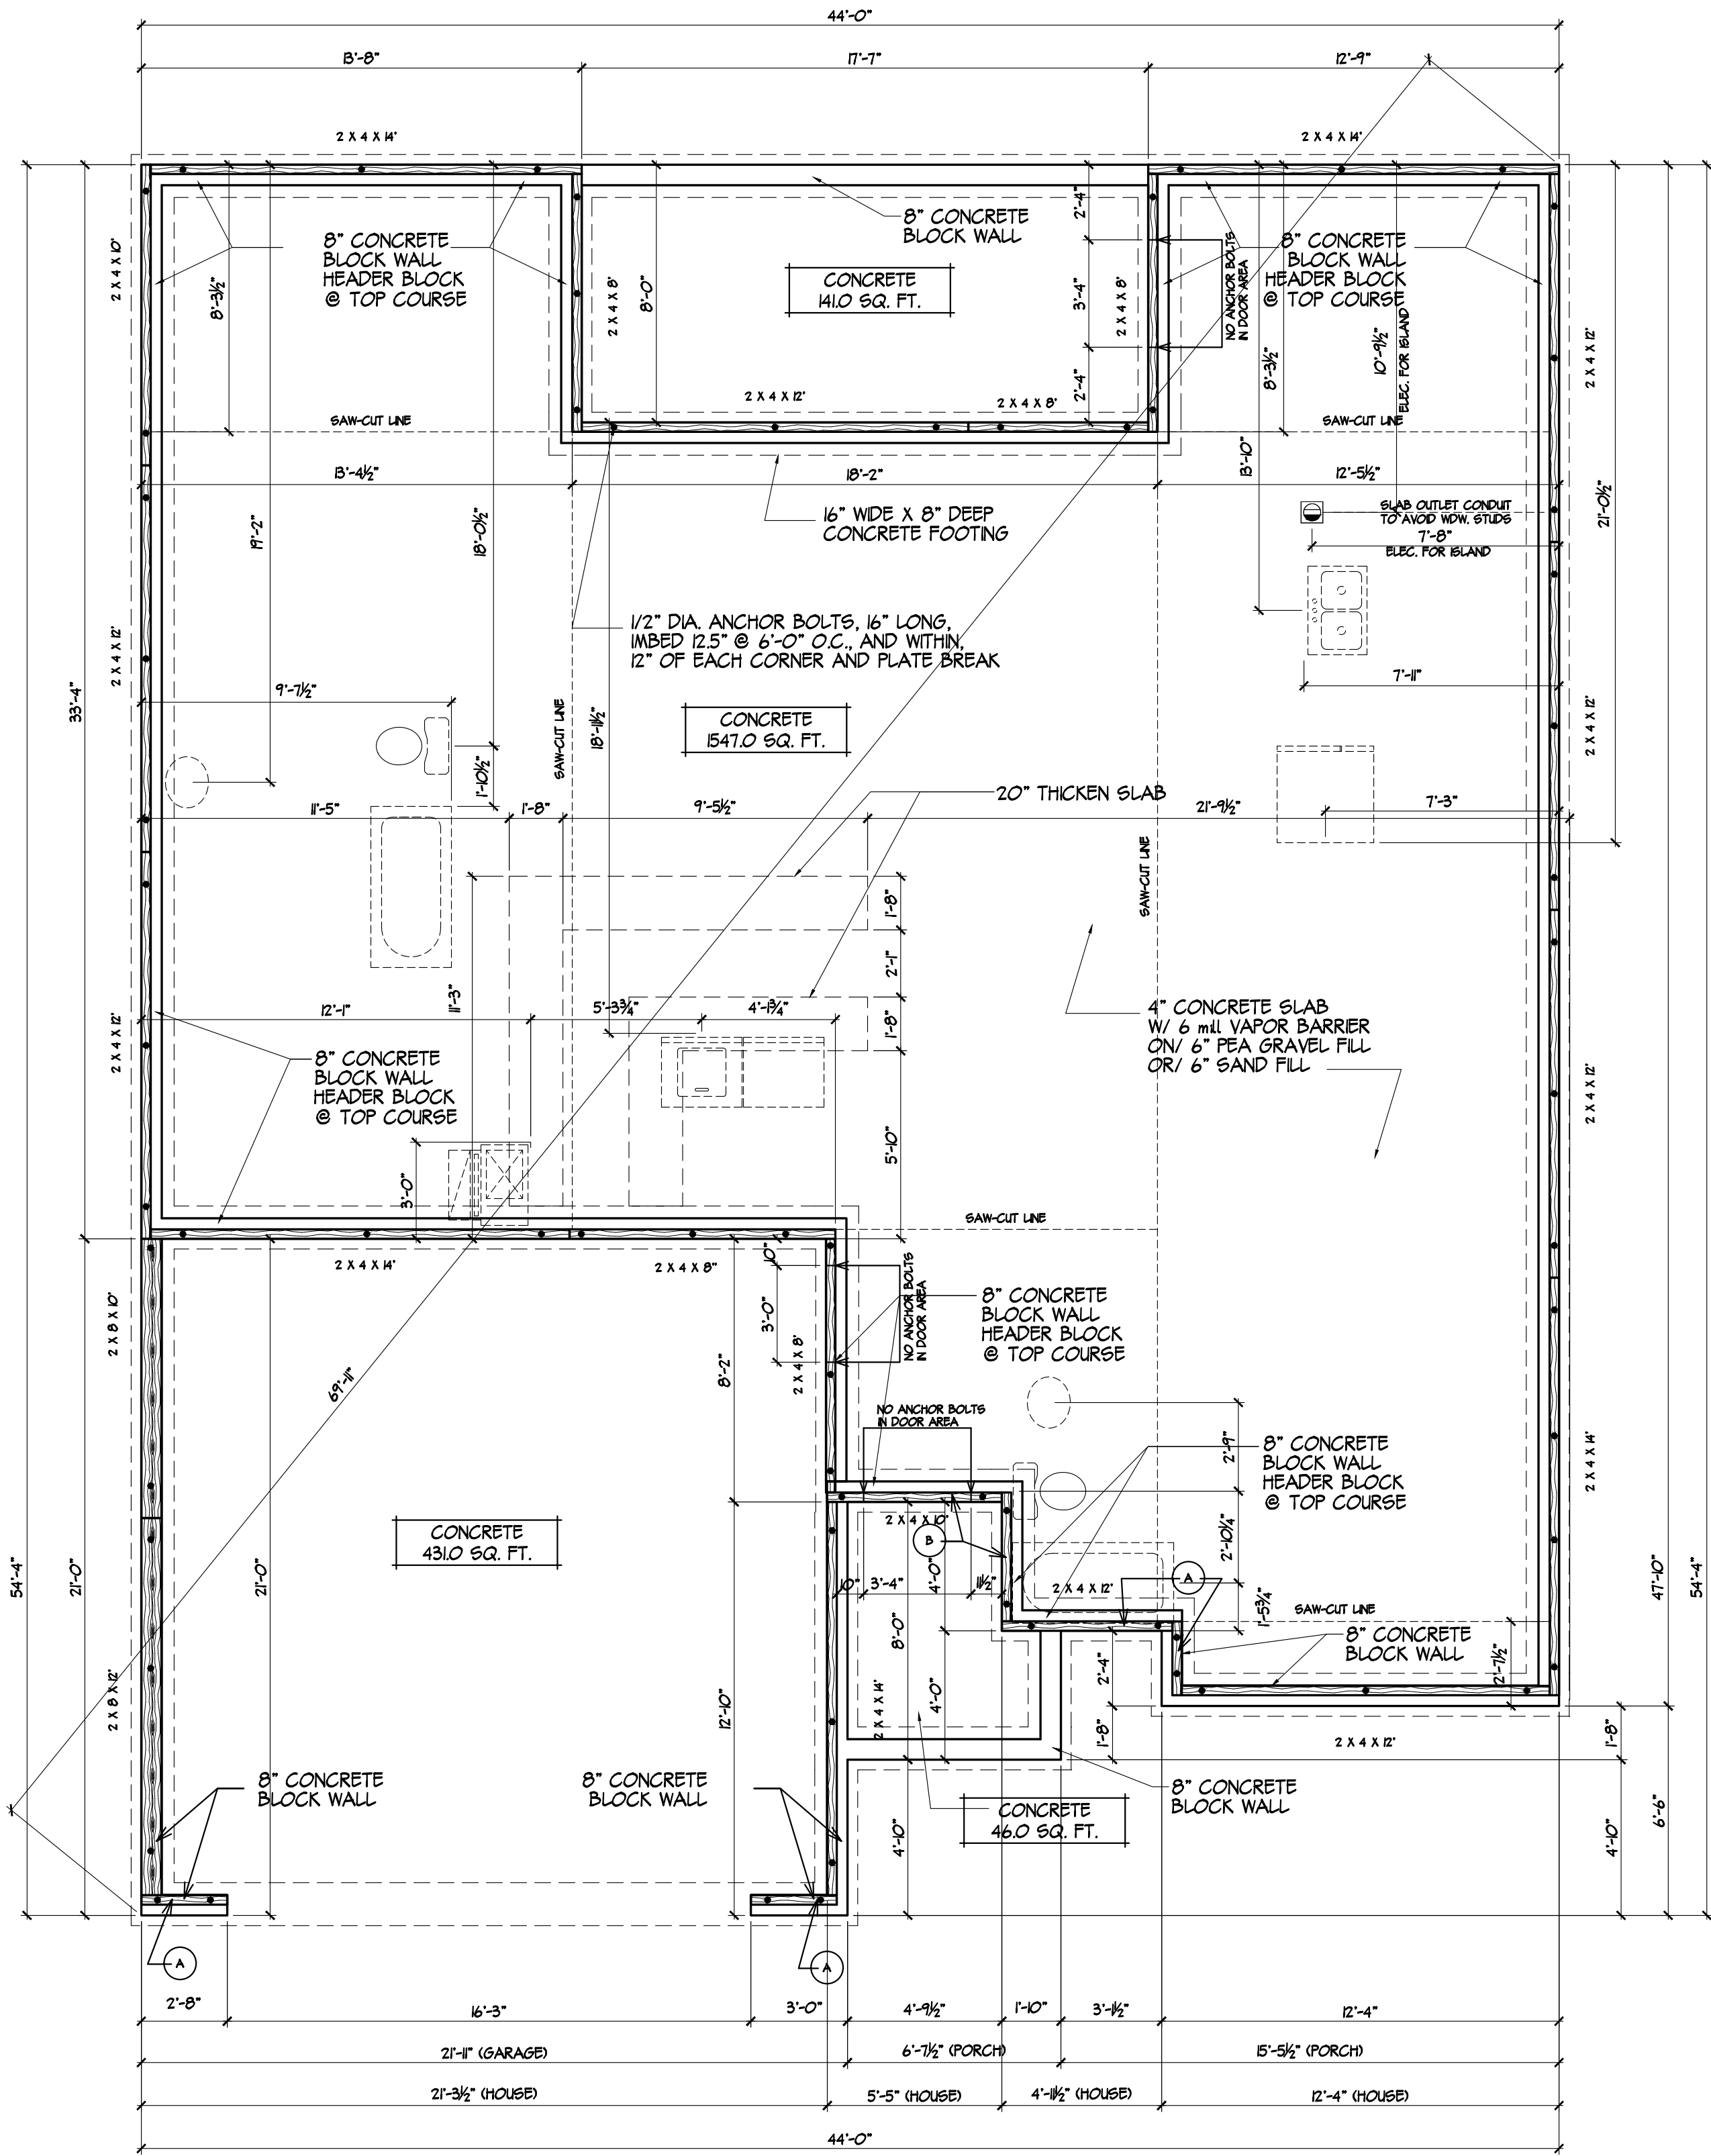

CUSTOMER NAME RESIDENCE

STREET ADDRESS
CITY, STATE & ZIP

LOT & SUBDIVISION

SUMMIT

FOUNDATION BONUS C

Sheet Number

S 1.1

DATE: February 06, 2025	
LAST SAVED BY: Terry.Gebhard	
LAST SAVED: Thu, 06 Feb 2025 - 1:07pm	
CREATED: Thu, 19 Jan 2012 - 3:36pm	
FILE NAME: SUMMIT AS OF 020725.dwg	
TIME PLOTTED: Thu, 06 Feb 2025 - 1:38pm	
REVISION: PDR#183 DATE:03/28/12 PDR#424 DATE:03/24/15 PDR# 594 DATE:02/28/17 PDR#730 DATE:10/12/18 PDR#000 DATE:00/00/00	

JAGOE HOMES




3624 WATHENS CROSSING
OWENSBORO, KENTUCKY 42301
(270) 684-0639




© 2001 Jagoe Homes, Inc. Unauthorized use of this plan is in violation of the U.S. Copyright Act, Title 17 of the U.S. Code. Reported square footage is approximate and based upon Architectural Design. Area and actual dimensions may vary according to construction methods. Dimensions used on floor plans are framing dimensions. Municipality requirements regarding size of foundation block may affect framing dimensions shown on plans. Brochures as shown by artist's renditions may not show all standards and options. Specifications may change without notice. Variations may occur by neighborhood, lot location, and home series. Not all plan brochures may be placed on every lot. Location of residence on lot shall be determined by Jagoe Homes Inc.

FLOOR AREA

1593.0 SQ. FT.	LIVING-BRICK/STONE
471.0 SQ. FT.	GARAGE - BRICK/STONE
41.0 SQ. FT.	REAR PORCH
46.0 SQ. FT.	FRONT PORCH
2251.0 SQ. FT.	

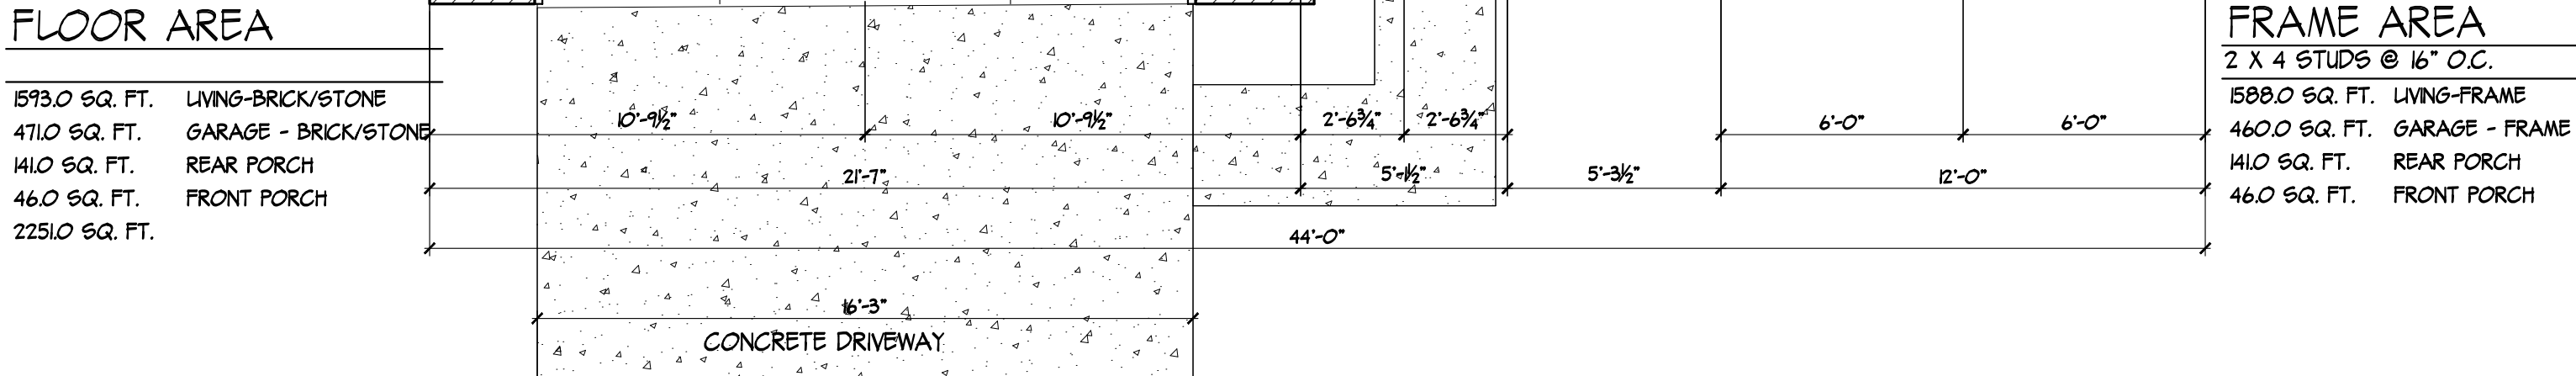

- GENERAL NOTES:
- SHOWER HEAD HEIGHT ROUGH-IN TO BE 84" AFF.
 - HOUSEWRAP BEHIND ALL TUBS & SHOWERS.
 - GARAGE DOOR JACKS TO BE MIN. 1/8", MAX. 1/4" OFF FIN. FLOOR.
 - EXTENDED JAMBS & CASING.
 - 2-1/4" CASING UNLESS NOTED OTHERWISE ON PLAN.
 - EXTERIOR FRAMING DIMENSIONS INCLUDE 1/2" FOR SHEATHING.
 - SEE ELECTRICAL PLAN FOR HVAC LOCATIONS.

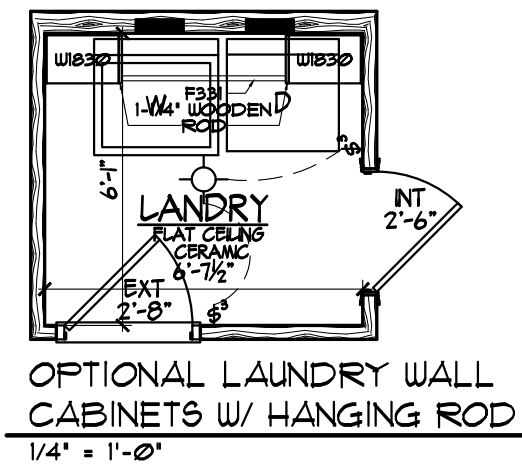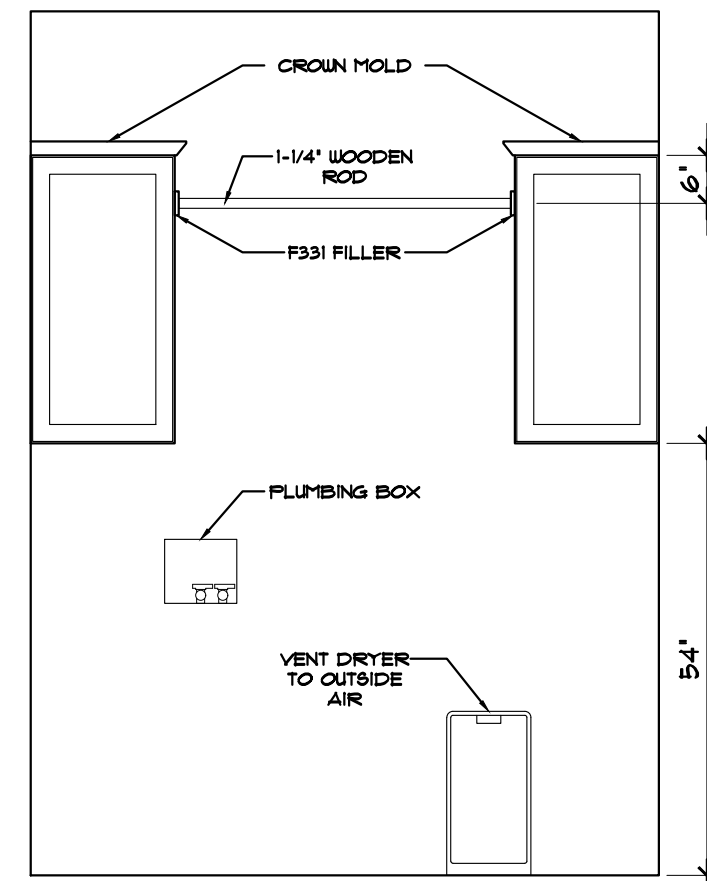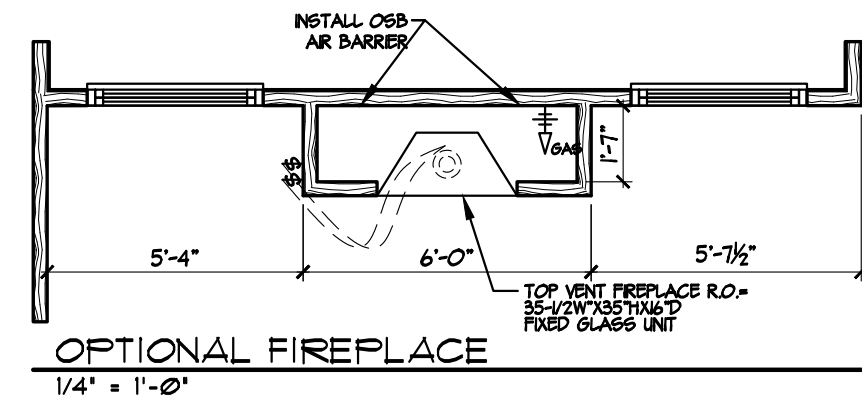

FRAME AREA

2 X 4 STUDS @ 16" O.C.
1588.0 SQ. FT. LIVING-FRAME
460.0 SQ. FT. GARAGE - FRAME
41.0 SQ. FT. REAR PORCH
46.0 SQ. FT. FRONT PORCH

CUSTOMER NAME RESIDENCE

STREET ADDRESS
CITY, STATE & ZIP
LOT & SUBDIVISION
SUMMIT

FLOOR PLAN BONUS C

Sheet Number


A1.1

DATE:	February 06, 2025
LAST SAVED BY:	Terry.Gebhard
LAST SAVED:	Thu, 06 Feb 2025 - 1:07pm
CREATED:	Thu, 19 Jan 2012 - 3:36pm
FILE NAME:	SUMMIT AS OF 020725.dwg
TIME PLOTTED:	Thu, 06 Feb 2025 - 1:39pm
REVISION:	
PDR#183	DATE:03/28/12
PDR#424	DATE:03/24/15
PDR# 594	DATE:02/28/17
PDR#730	DATE:10/12/18
PDR#000	DATE:00/00/00



JAGOE HOMES

3624 WATHENS CROSSING
OWENSBORO, KENTUCKY 42301
(270) 684-0639

© 2001 Jagoe Homes, Inc. Unauthorized use of this plan is in violation of the U.S. Copyright Act, Title 17 of the U.S. Code. Reported square footage is approximate and based upon Architectural Design. Area and actual dimensions may vary according to construction methods. Dimensions used on floor plans are framing dimensions. Municipality requirements regarding size of foundation block may affect framing dimensions shown on plans. Brochures as shown by artist's renditions may not show all standards and options. Specifications may change without notice. Variations may occur by neighborhood, lot location, and home series. Not all plan brochures may be placed on every lot. Location of residence on lot shall be determined by Jagoe Homes Inc.

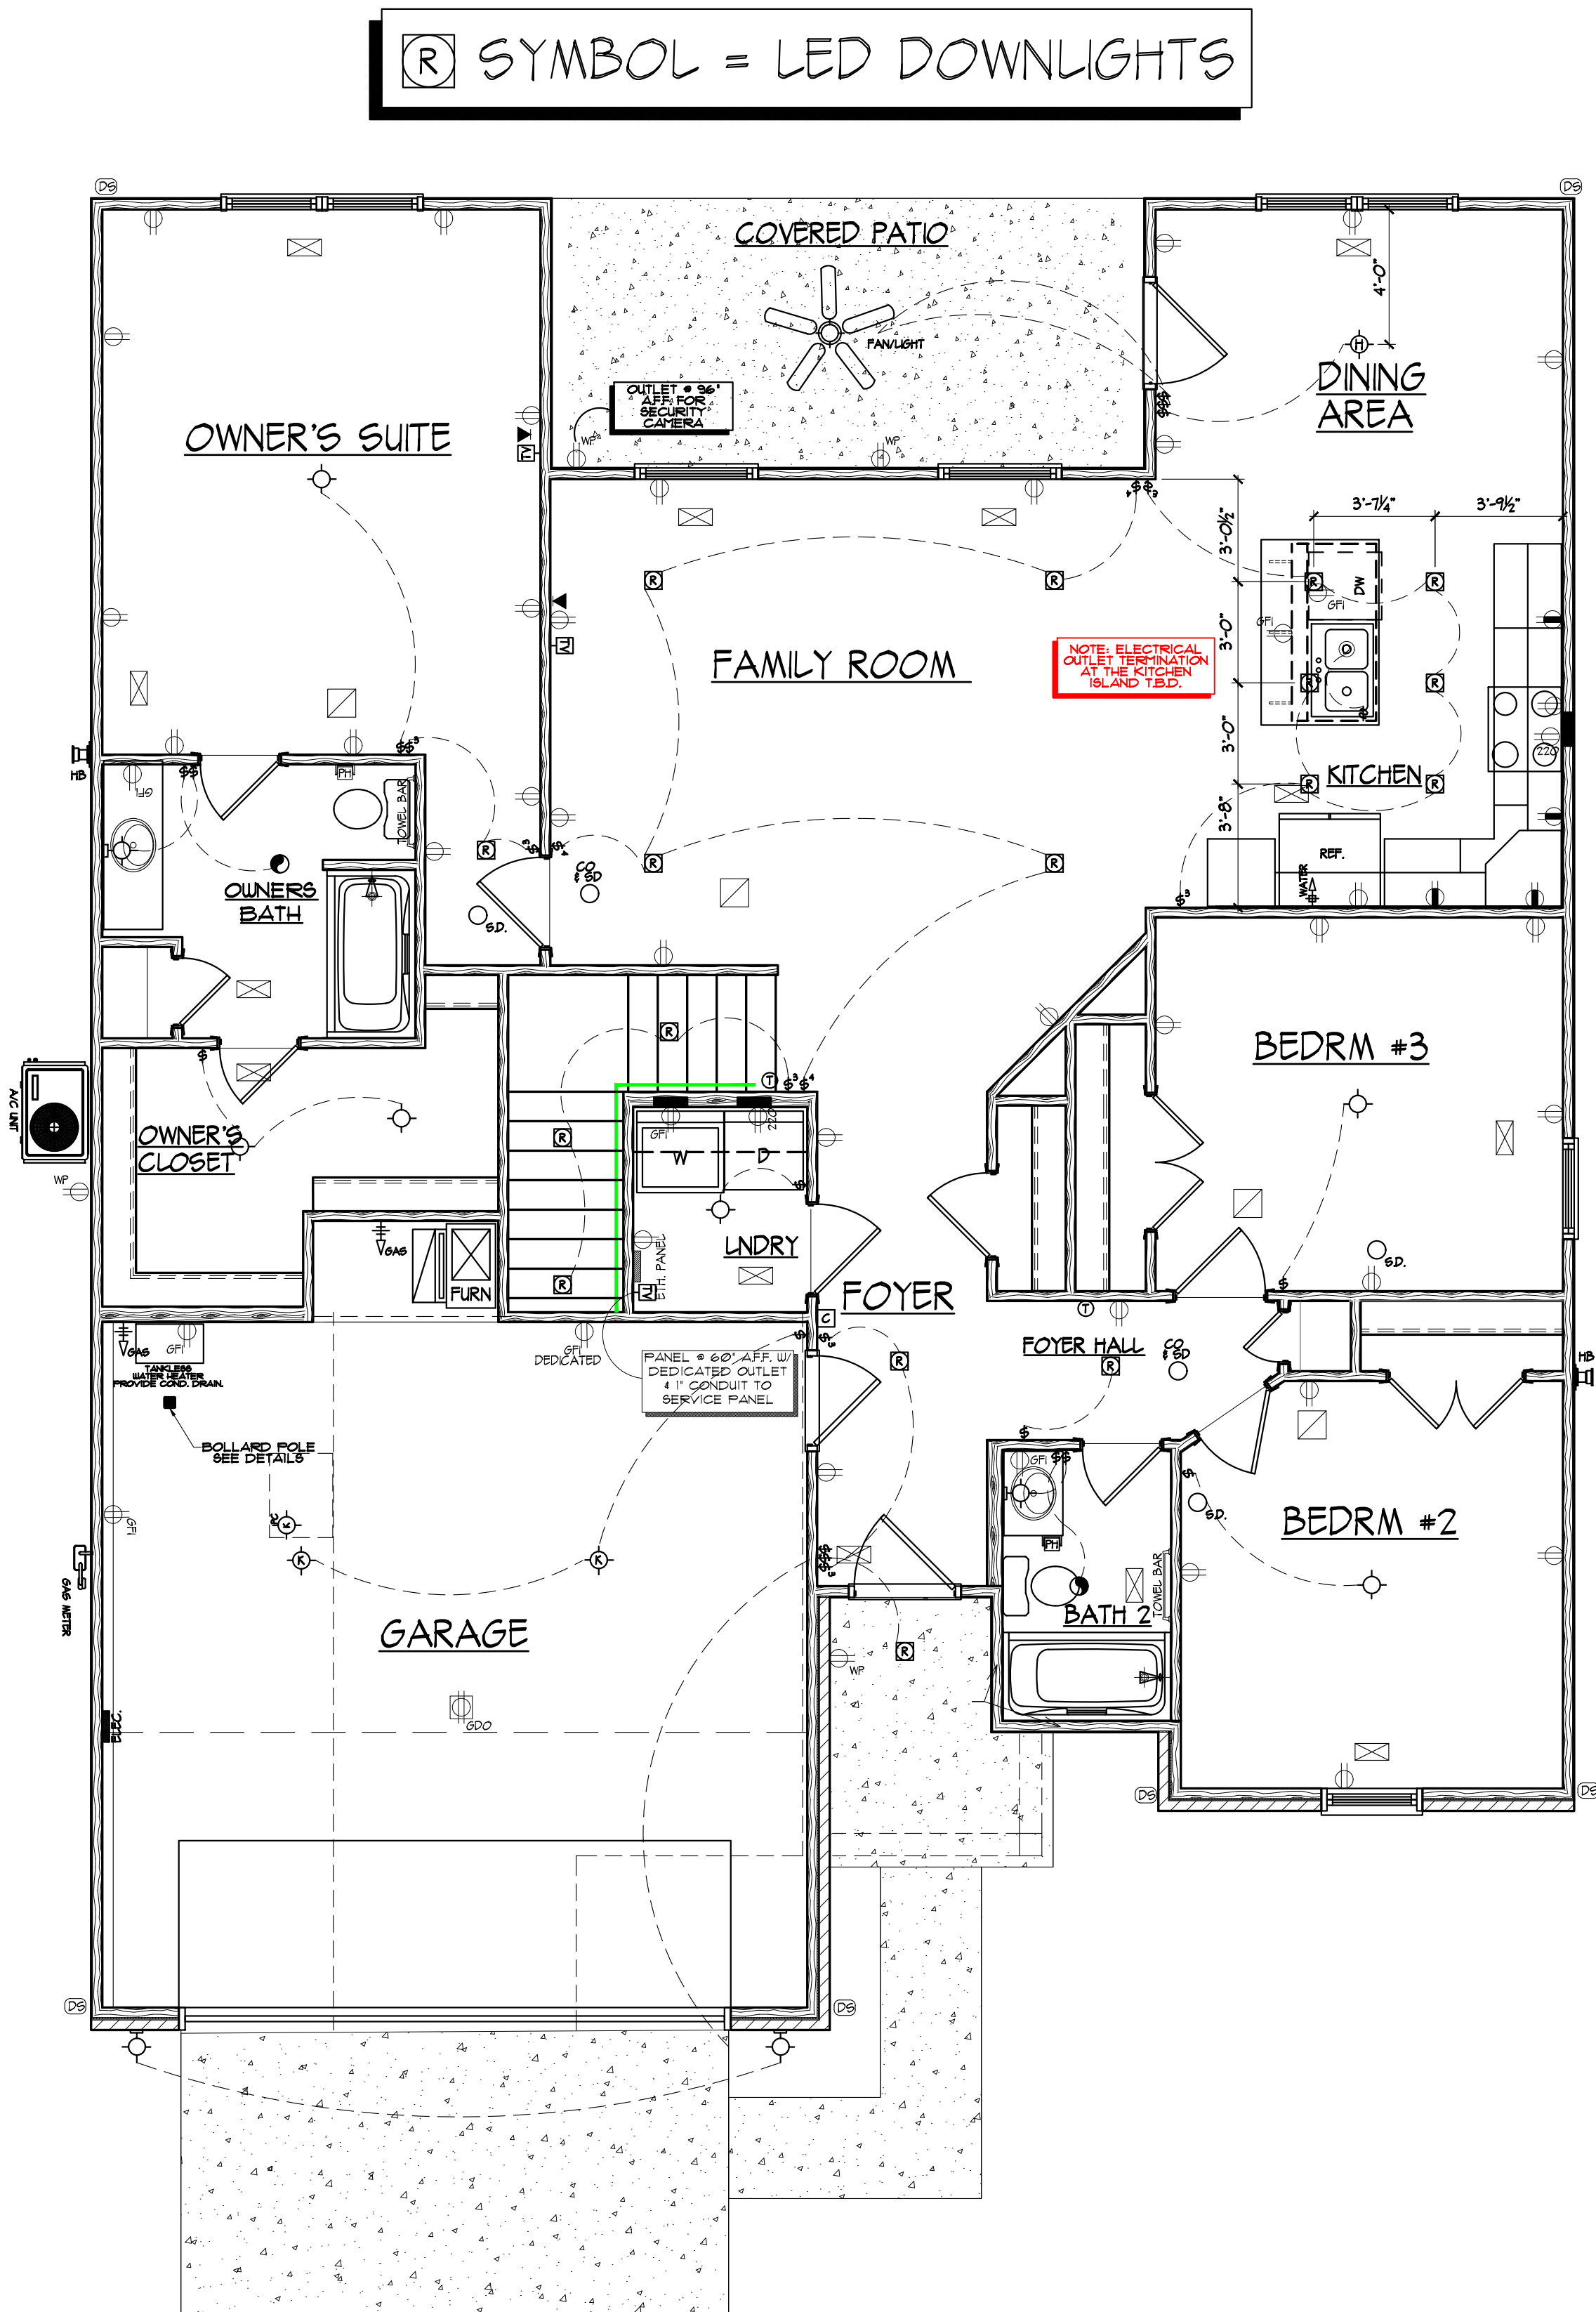

NOTE :
FIXTURE LOCATIONS MAY BE ADJUSTED ON SITE DUE TO STRUCTURAL OR MECHANICAL LOCATIONS.
STRUCTURED WIRING PANEL TO INCLUDE THE FOLLOWING :
(1) LEGRAND EFN3050 PLASTIC ENCLOSED PANEL W/ HINGED DOOR, OR EQUIV.
(1) DEDICATED 110V OUTLET
(1) COAX FROM PANEL TO EXTERIOR SERVICE
(1) 1" CONDUIT W/ FULL STRING TO EXTERIOR SERVICE
ALL SHIELDED CAT6 TO BE HOMERUN TO SERVICE PANEL WITH MALE TERMINATION AT PANEL AND FEMALE TERMINATION WALL PLATE AT DESIGNATED LOCATIONS THROUGHOUT THE HOUSE
SEE KITCHEN ELEVATION DETAILS FOR HORIZONTAL OUTLET LOCATIONS.
ALL ELECTRICAL OUTLETS TO BE 12" AFF. TO BOTTOM OF BOX UNLESS OTHERWISE NOTED.
MECHANICAL LOCATIONS MAY VARY DUE TO STRUCTURAL OR ON SITE CONDITIONS.

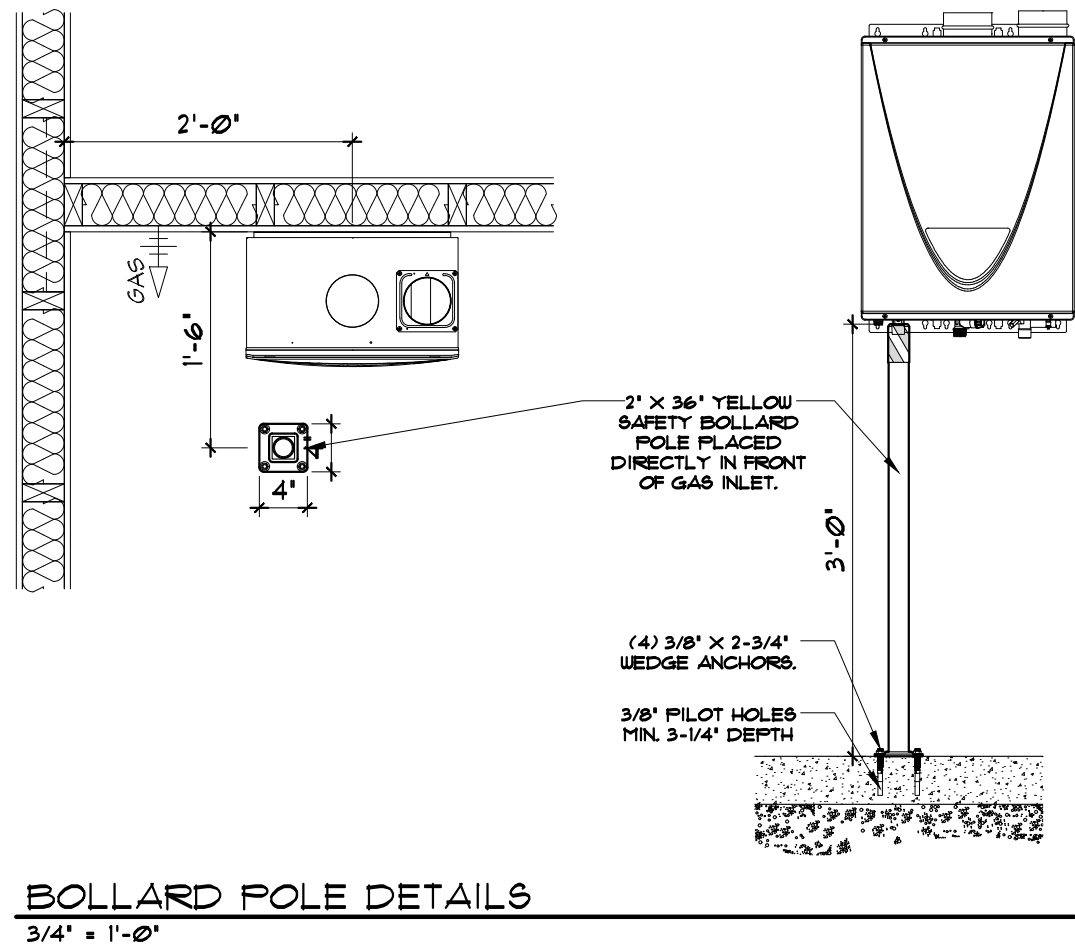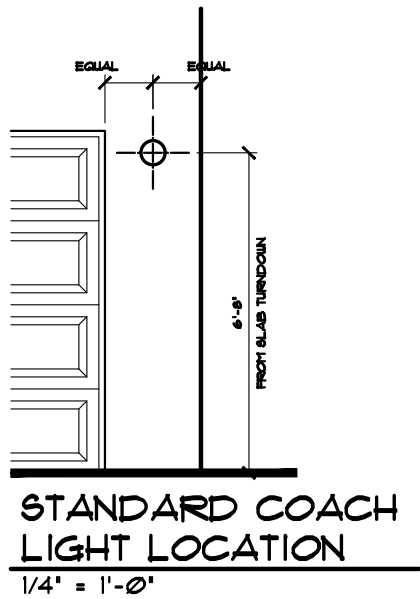

ELECTRICAL LEGEND	
SYMBOL	DESCRIPTION
	WIRE SWITCHING & CONNECTIONS
	DUPLEX OUTLET (GROUNDED TYPE)
	DOUBLE DUPLEX OUTLET (QUAD) (GROUNDED TYPE)
	GROUND FAULT INTERRUPTER DUPLEX OUTLET
	WEATHER PROOF GFI DUPLEX OUTLET
	WALL SWITCH CONTROLLED DUPLEX OUTLET
	ABOVE COUNTER LOCATION **SEE NOTE BELOW**
	E3902 & KITCHEN RECEPTACLES, 125-VOLT, SINGLE PHASE, 15-AND 20-AMPERE RECEPTACLES THAT SERVE COUNTERTOP SURFACES SHALL HAVE GROUND-FAULT CIRCUIT-INTERRUPTER PROTECTION FOR PERSONNEL.
	FLUSH FLOOR DUPLEX OUTLET (OWNER VERIFY)
	220 VOLT OUTLET OR CONNECTION
	CEILING MOUNTED OUTLET FOR GARAGE DOOR
	SINGLE POLE WALL SWITCH
	3-WAY WALL SWITCH
	SINGLE POLE WALL SWITCH WITH DIMMER
	3-WAY WALL SWITCH WITH DIMMER
	OVER / UNDER SWITCH
	CEILING MOUNTED LIGHT FIXTURE
	CEILING MOUNTED KEYLESS LIGHT FIXTURE
	CEILING MOUNT KEYLESS LIGHT W/ PULL CHAIN
	WALL BRACKET MOUNTED LIGHT FIXTURE
	HANGING CEILING MOUNTED LIGHT FIXTURE
	RECESSED DIRECTIONAL CEILING LIGHT FIXTURE (EYEBALL)
	LED DOWNLIGHT
	RECESSED LIGHT FOR WET AREA
	CEILING MOUNTED FAN - EXHAUST
	CEILING MOUNTED FAN AND LIGHT
	UNDER CABINET LIGHTING
	STARWAY STEP LIGHTS
	EXTERIOR CAST ALUMINUM FLOOD LIGHTS
	'SATCO' 7" LED LIGHT
	'SATCO' 9" LED LIGHT
	TELEPHONE OUTLET
	TELEVISION ANTENNA / CABLE OUTLET
	CAT 6 OUTLET
	120 VOLT ELECTRICAL PANEL
	DOOR BELL BUTTON
	DOOR CHIME LOCATION
	THERMOSTAT LOCATION
	SINK GARBAGE DISPOSAL
	SMOKE DETECTOR
	COMBINATION CARBON MONOXIDE & SMOKE DETECTOR
	FAN/LIGHT
	FAN ONLY

CUSTOMER NAME RESIDENCE

STREET ADDRESS

CITY, STATE & ZIP

LOT & SUBDIVISION

SUMMIT

FLOOR PLAN BONUS C ELECT.

Sheet Number

A1.1

DATE:
February 06, 2025

LAST SAVED BY:
Terry.Gebhard

LAST SAVED:
Thu, 06 Feb 2025 - 1:07pm

CREATED:
Thu, 19 Jan 2012 - 3:36pm


FILE NAME:
SUMMIT AS OF 020725.dwg

TIME PLOTTED:
Thu, 06 Feb 2025 - 1:39pm

REVISION:
PDR#183 DATE:03/28/12
PDR#424 DATE:03/24/15
PDR# 594 DATE:02/28/17
PDR#730 DATE:10/12/18
PDR#000 DATE:00/00/00

JAGOE HOMES

3624 WATHENS CROSSING
OWENSBORO, KENTUCKY 42301
(270) 684-0639

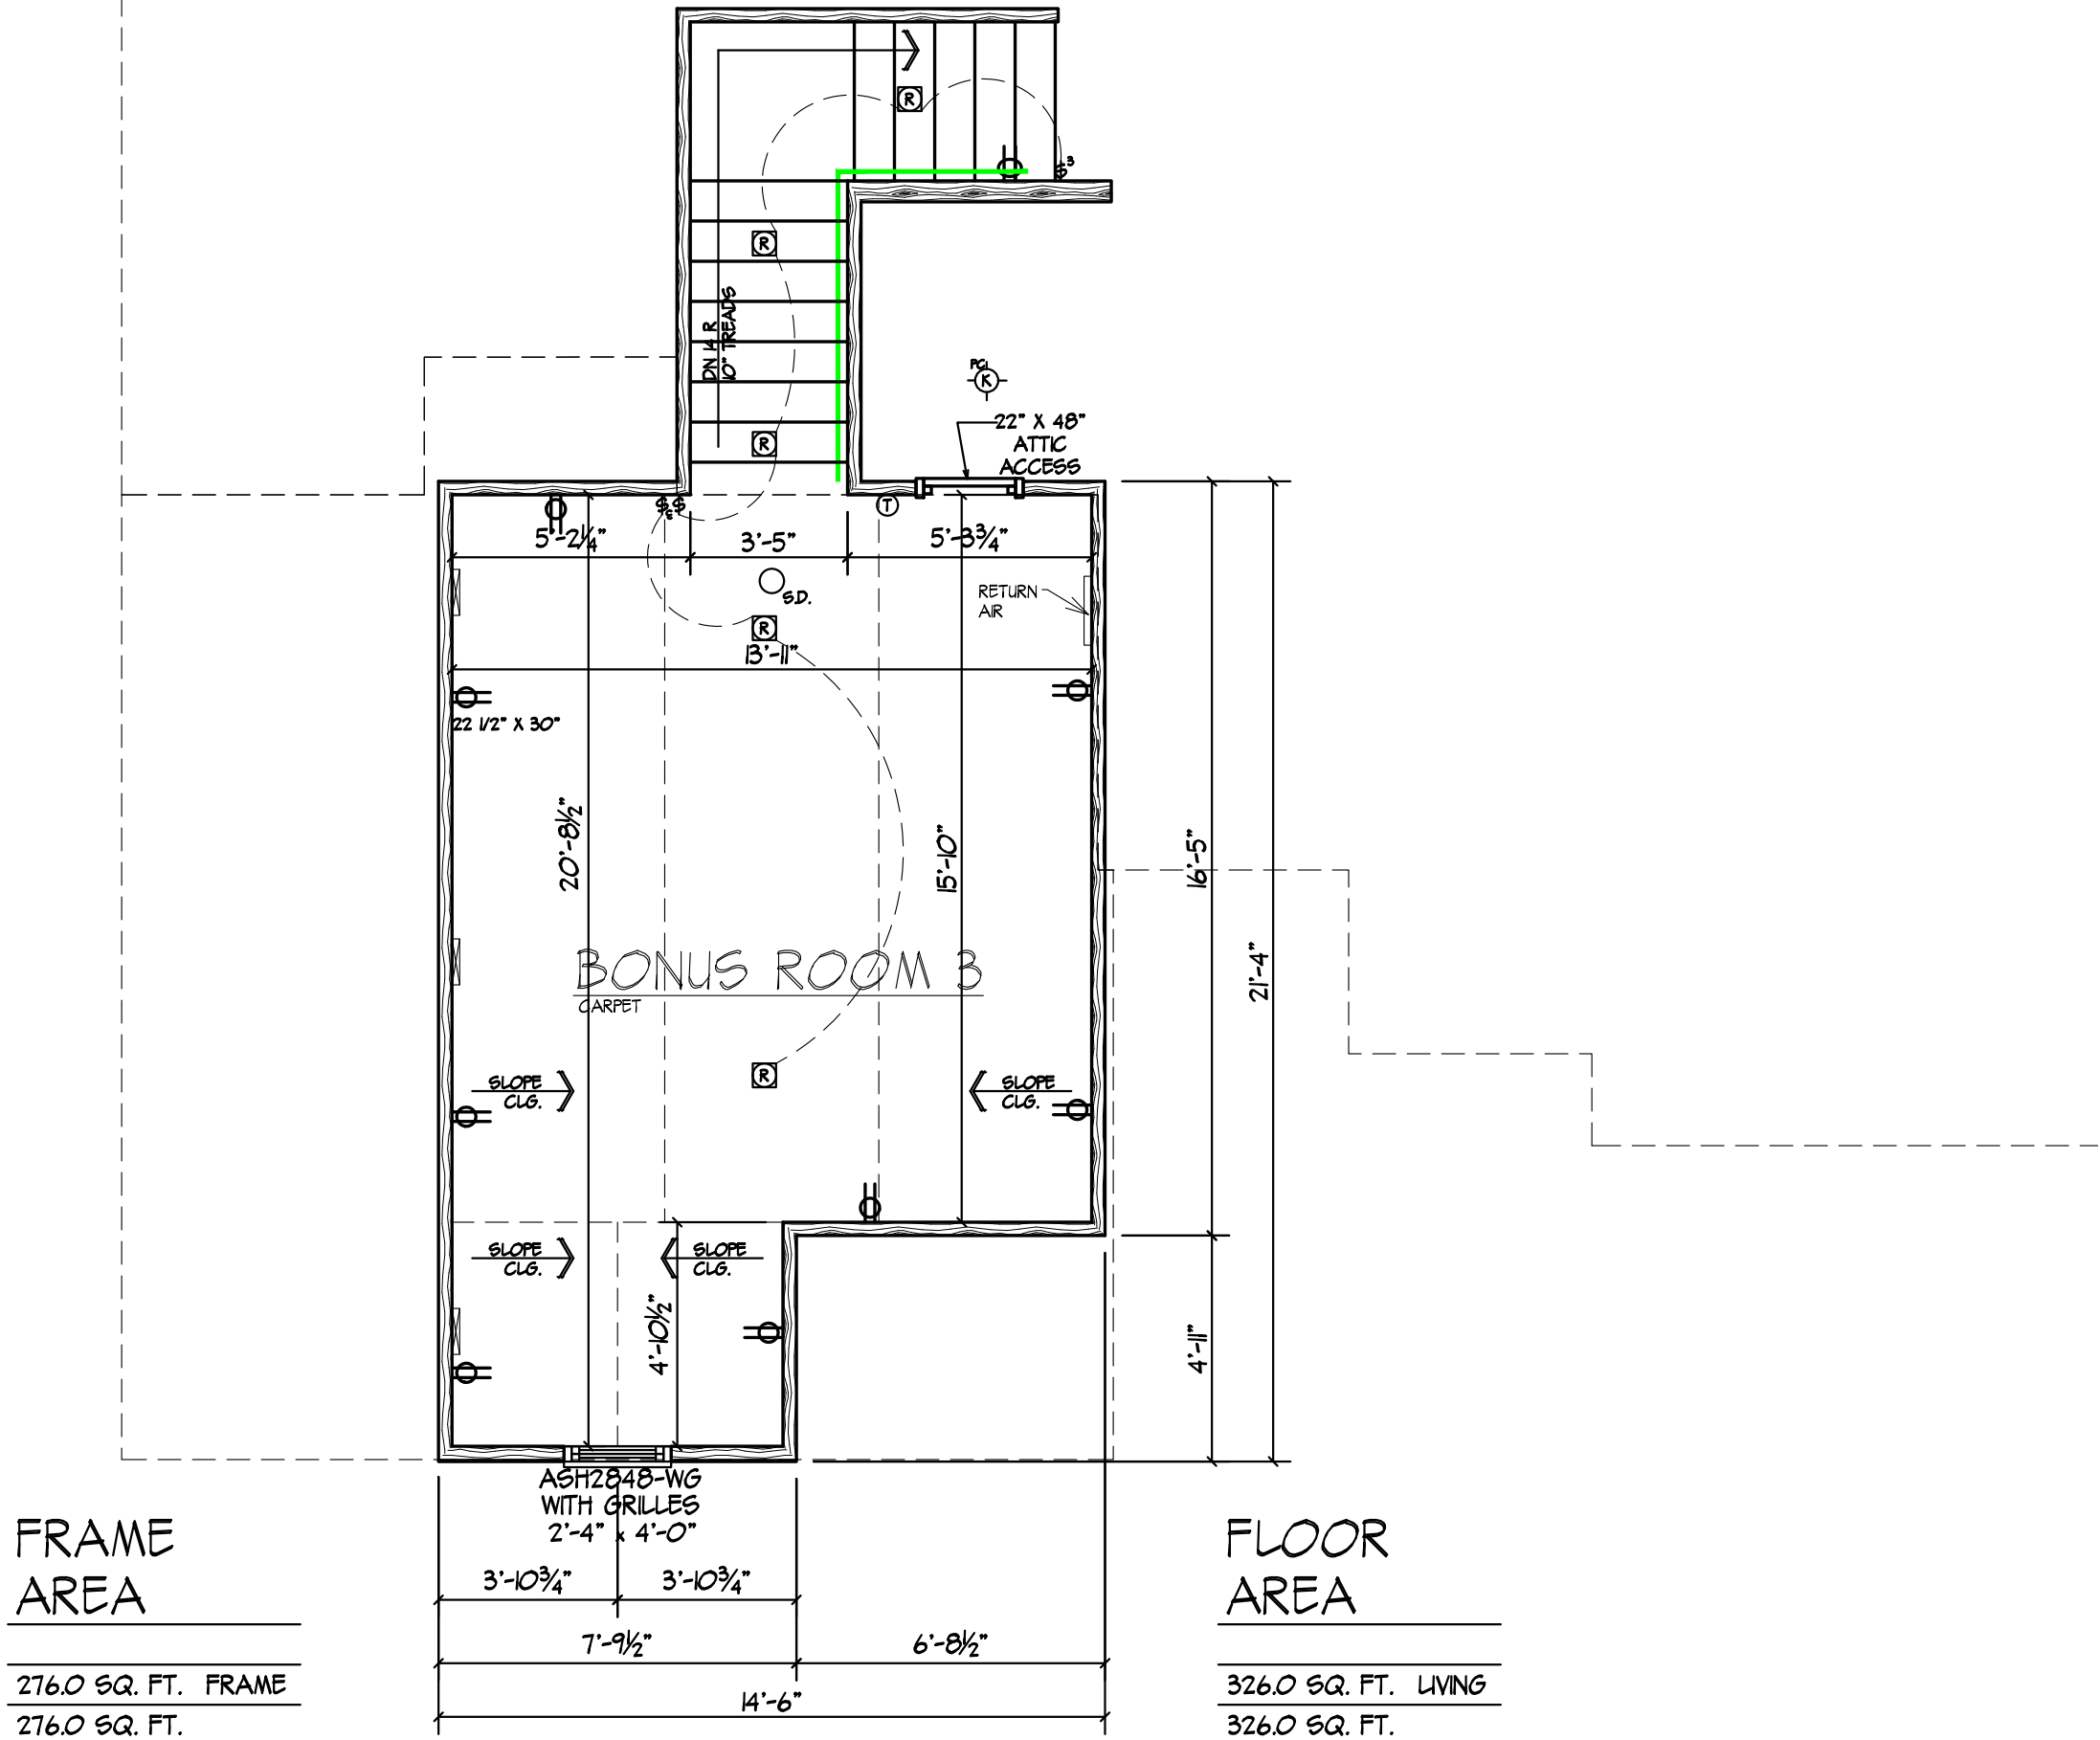

DATE: February 06, 2025	
LAST SAVED BY: Terry.Gebhard	
LAST SAVED: Thu, 06 Feb 2025 - 1:07pm	
CREATED: Thu, 19 Jan 2012 - 3:36pm	
FILE NAME: SUMMIT AS OF 020725.dwg	
TIME PLOTTED: Thu, 06 Feb 2025 - 1:39pm	
REVISION:	
PDR#183	DATE:03/28/12
PDR#424	DATE:03/24/15
PDR# 594	DATE:02/28/17
PDR#730	DATE:10/12/18
PDR#000	DATE:00/00/00

CUSTOMER NAME RESIDENCE	
STREET ADDRESS	
CITY, STATE & ZIP	
LOT & SUBDIVISION	
SUMMIT	
BONUS ROOM C & C1	

Sheet Number

A1.2

JAGOE
HOMES

3624 WATHENS CROSSING
OWENSBORO, KENTUCKY 42301
(270) 684-0639

DATE:	
February 06, 2025	
LAST SAVED BY:	
Terry.Gebhard	
LAST SAVED:	
Thu, 06 Feb 2025 - 1:07pm	
CREATED:	
Thu, 19 Jan 2012 - 3:36pm	
FILE NAME:	
SUMMIT AS OF 020725.dwg	
TIME PLOTTED:	
Thu, 06 Feb 2025 - 1:40pm	
REVISION:	
PDR#183	DATE:03/28/12
PDR#424	DATE:03/24/15
PDR# 594	DATE:02/28/17
PDR#730	DATE:10/12/18
PDR#000	DATE:00/00/00


CUSTOMER NAME RESIDENCE

STREET ADDRESS
CITY, STATE & ZIP
LOT & SUBDIVISION
SUMMIT


FRONT & REAR BONUS C

Sheet Number


A2.1

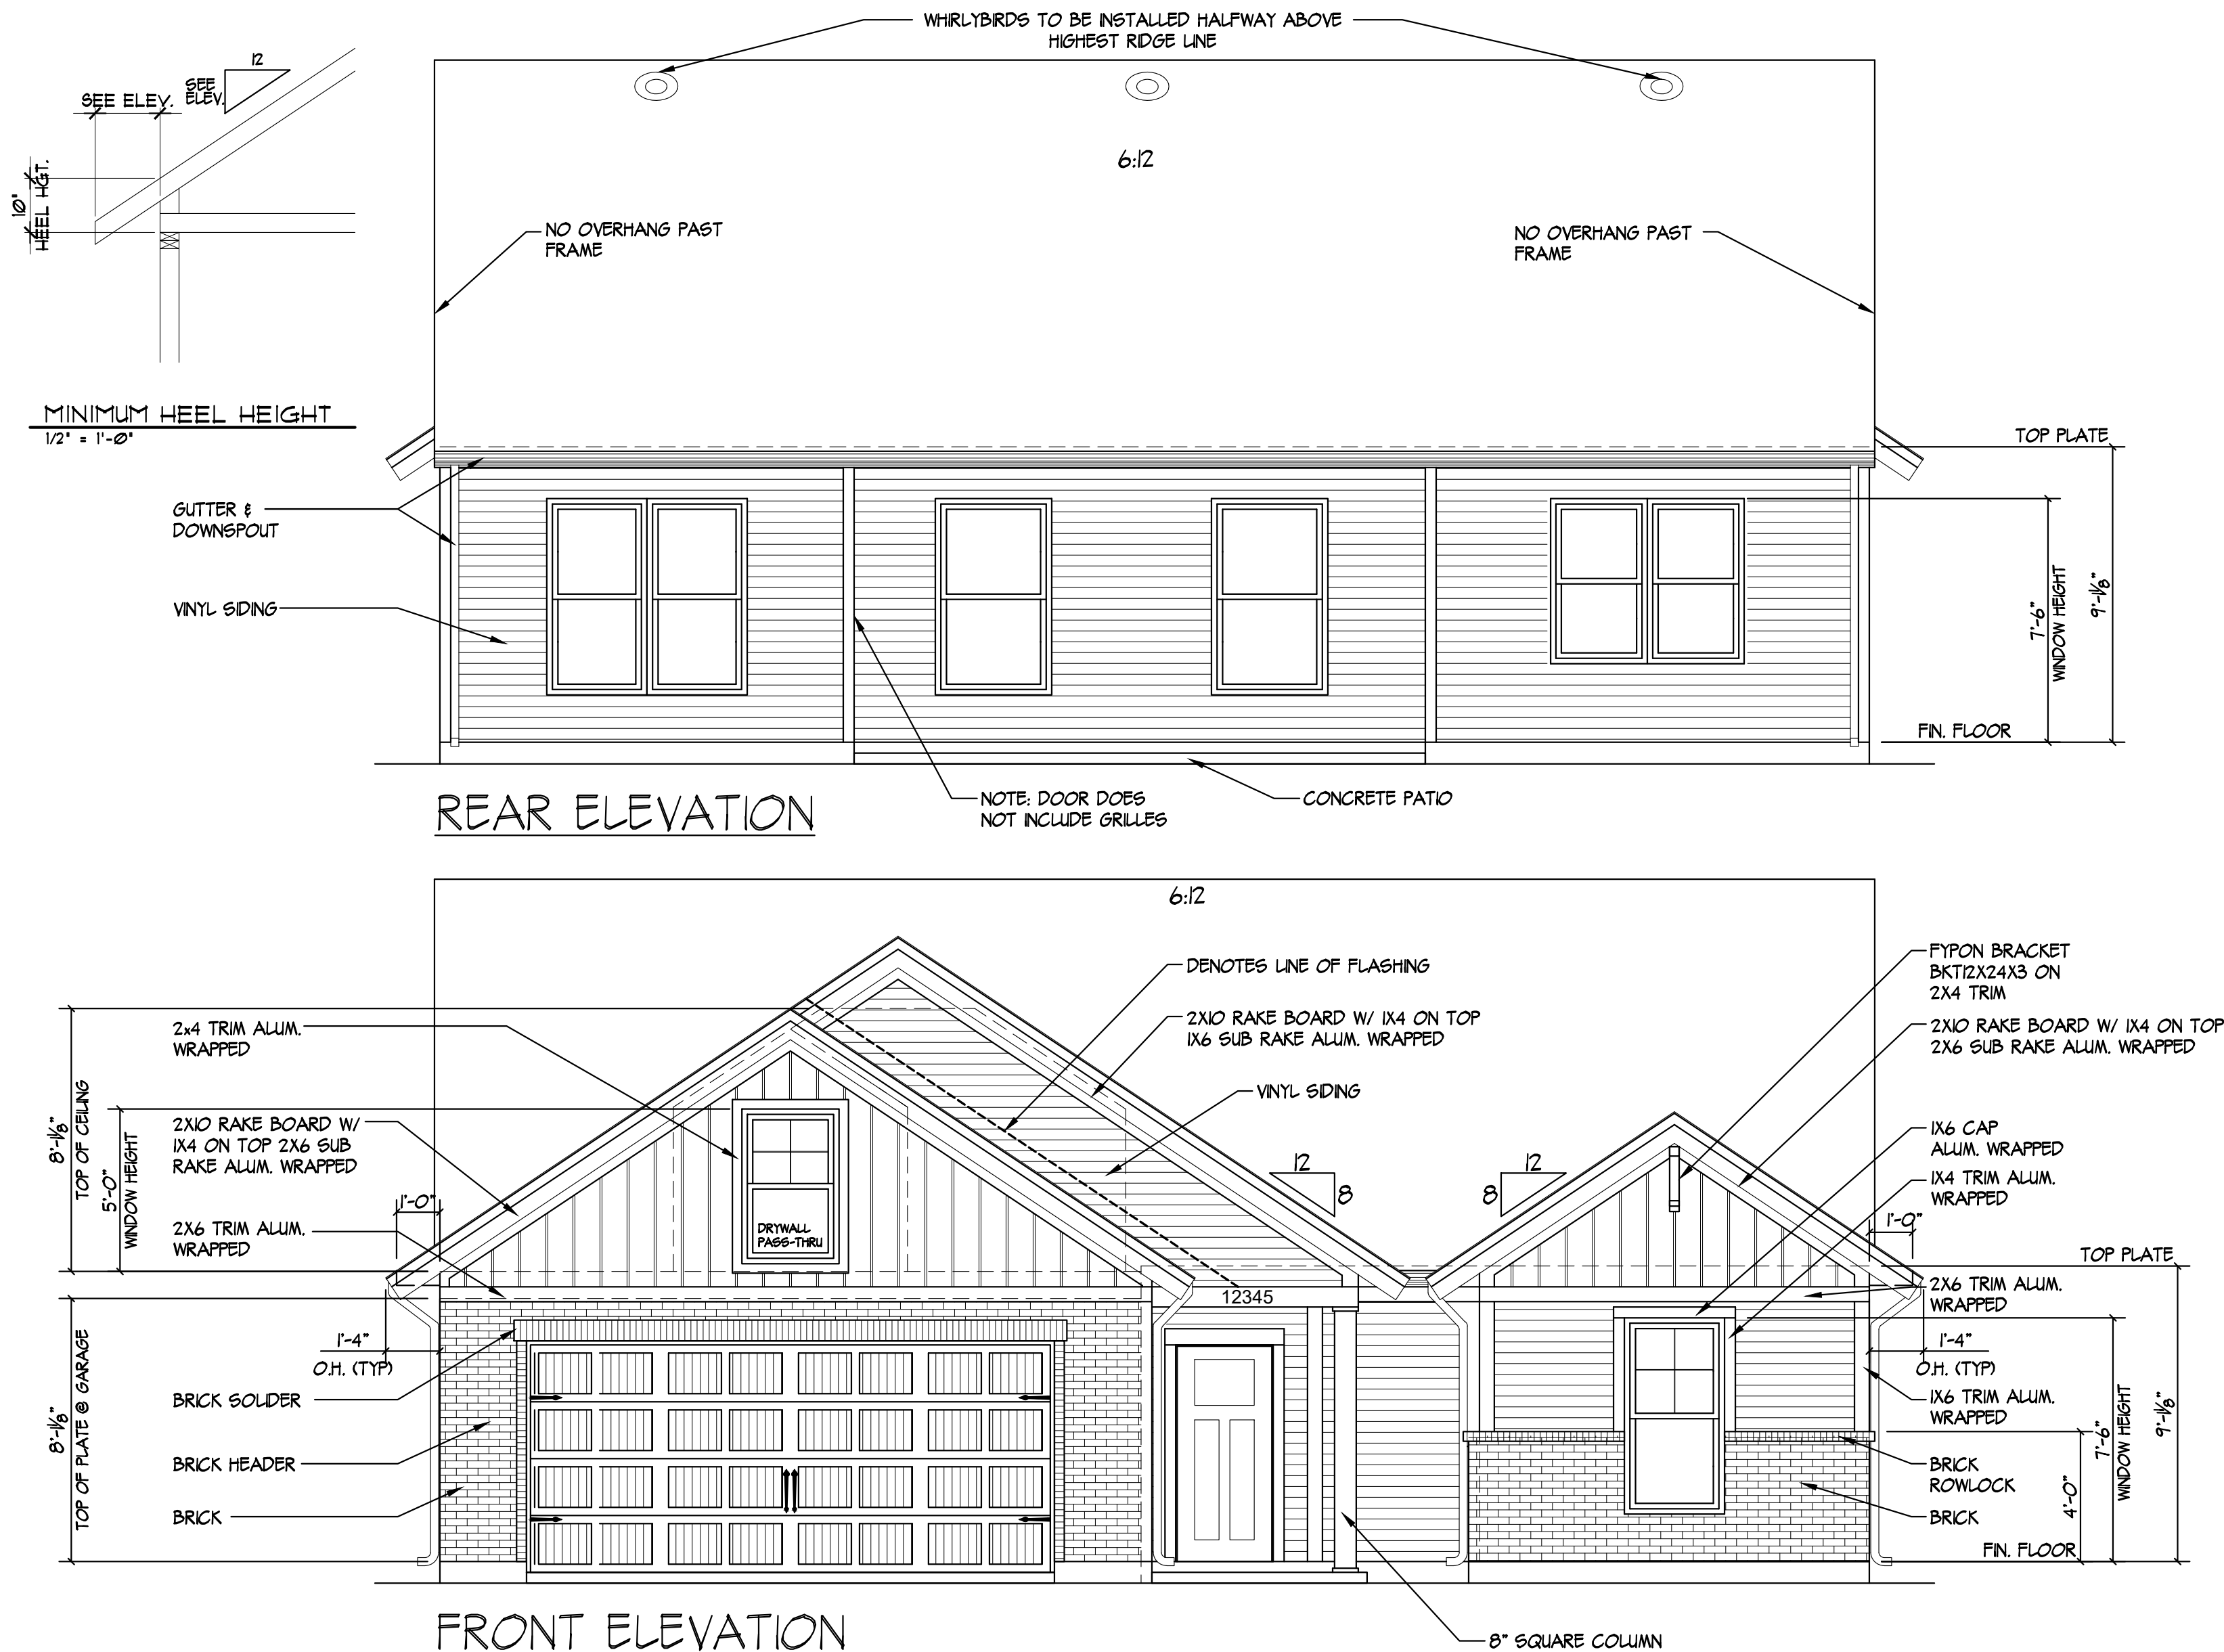

© 2001 Jagoe Homes, Inc. Unauthorized use of this plan is in violation of the U.S. Copyright Act, Title 17 of the U.S. Code. Reported square footage is approximate and based upon Architectural Design. Area and actual dimensions may vary according to construction methods. Dimensions used on floor plans are framing dimensions. Municipality requirements regarding size of foundation block may affect framing dimensions shown on plans. Brochures as shown by artist's renditions may not show all standards and options. Specifications may change without notice. Variations may occur by neighborhood, lot location, and home series. Not all plan brochures may be placed on every lot. Location of residence on lot shall be determined by Jagoe Homes Inc.

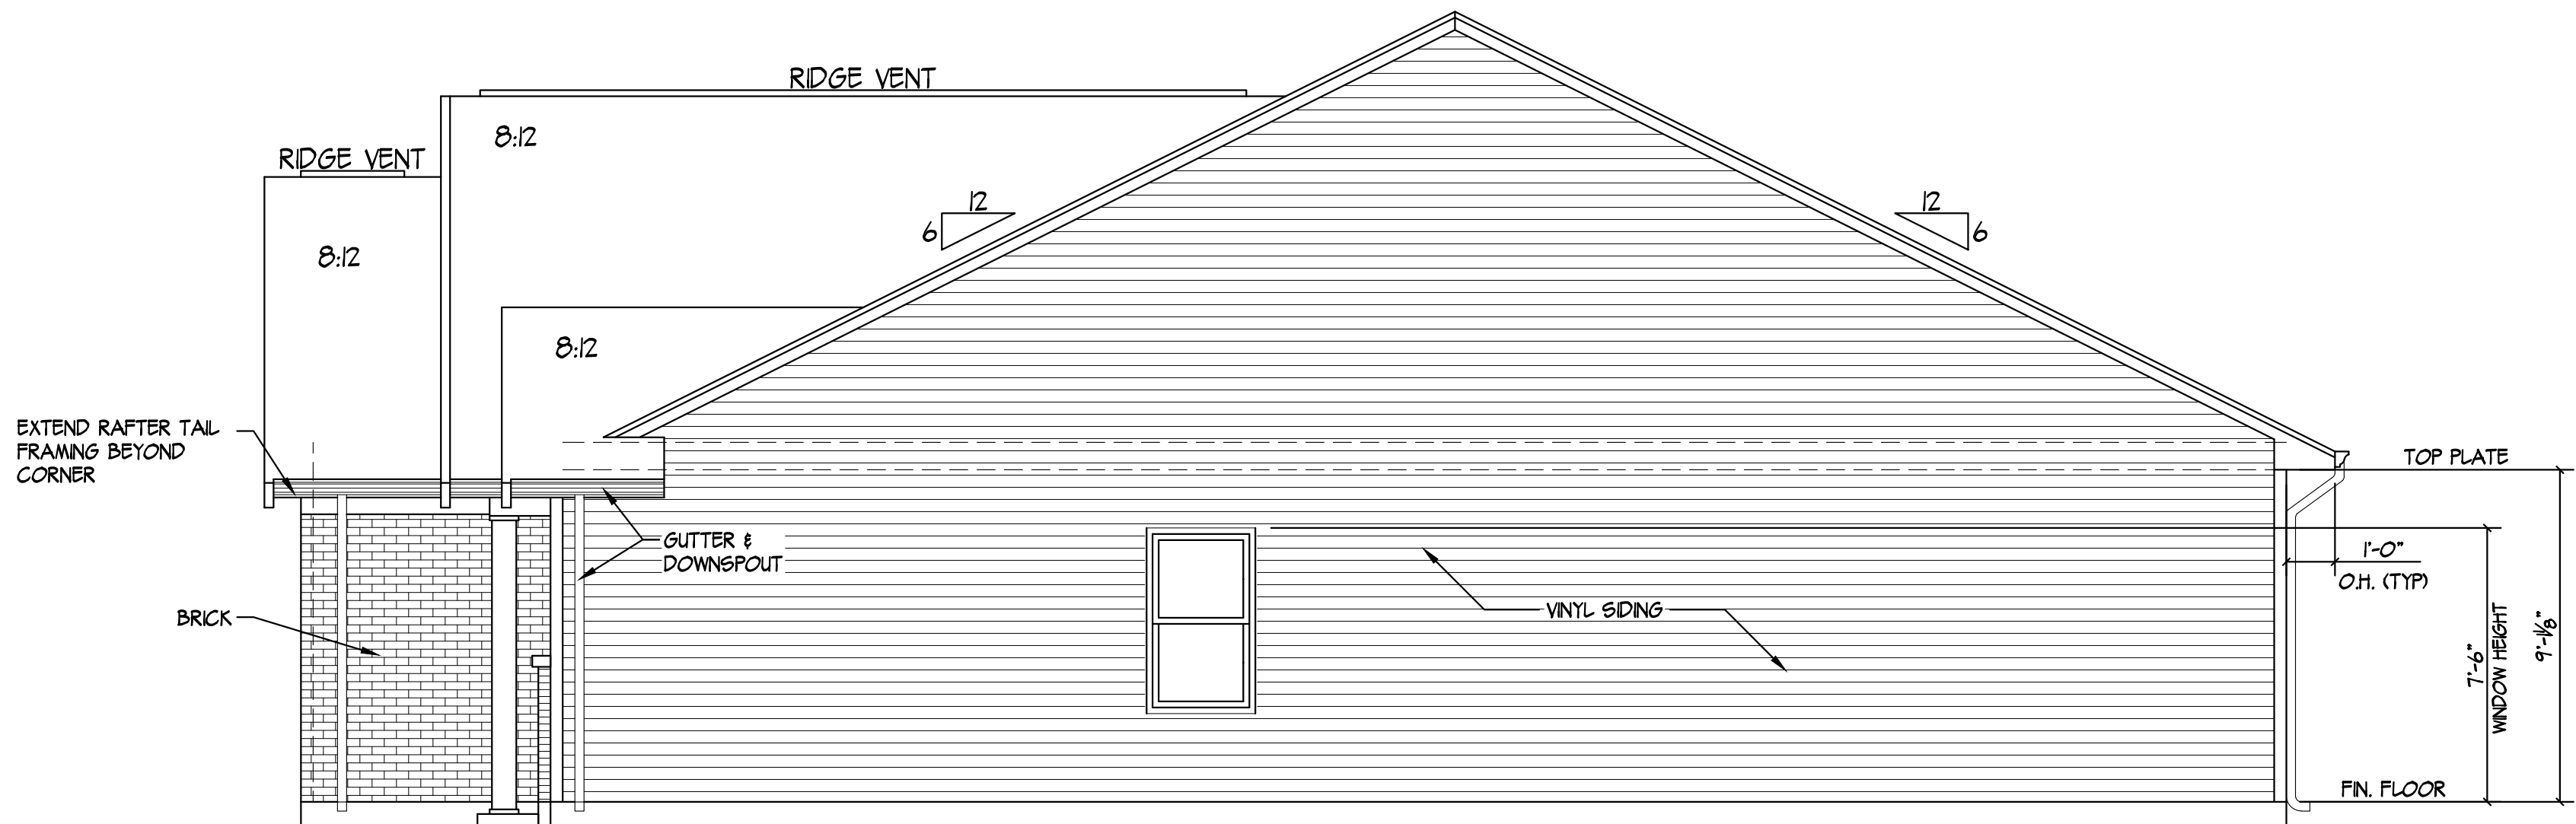

SIDE ELEVATION

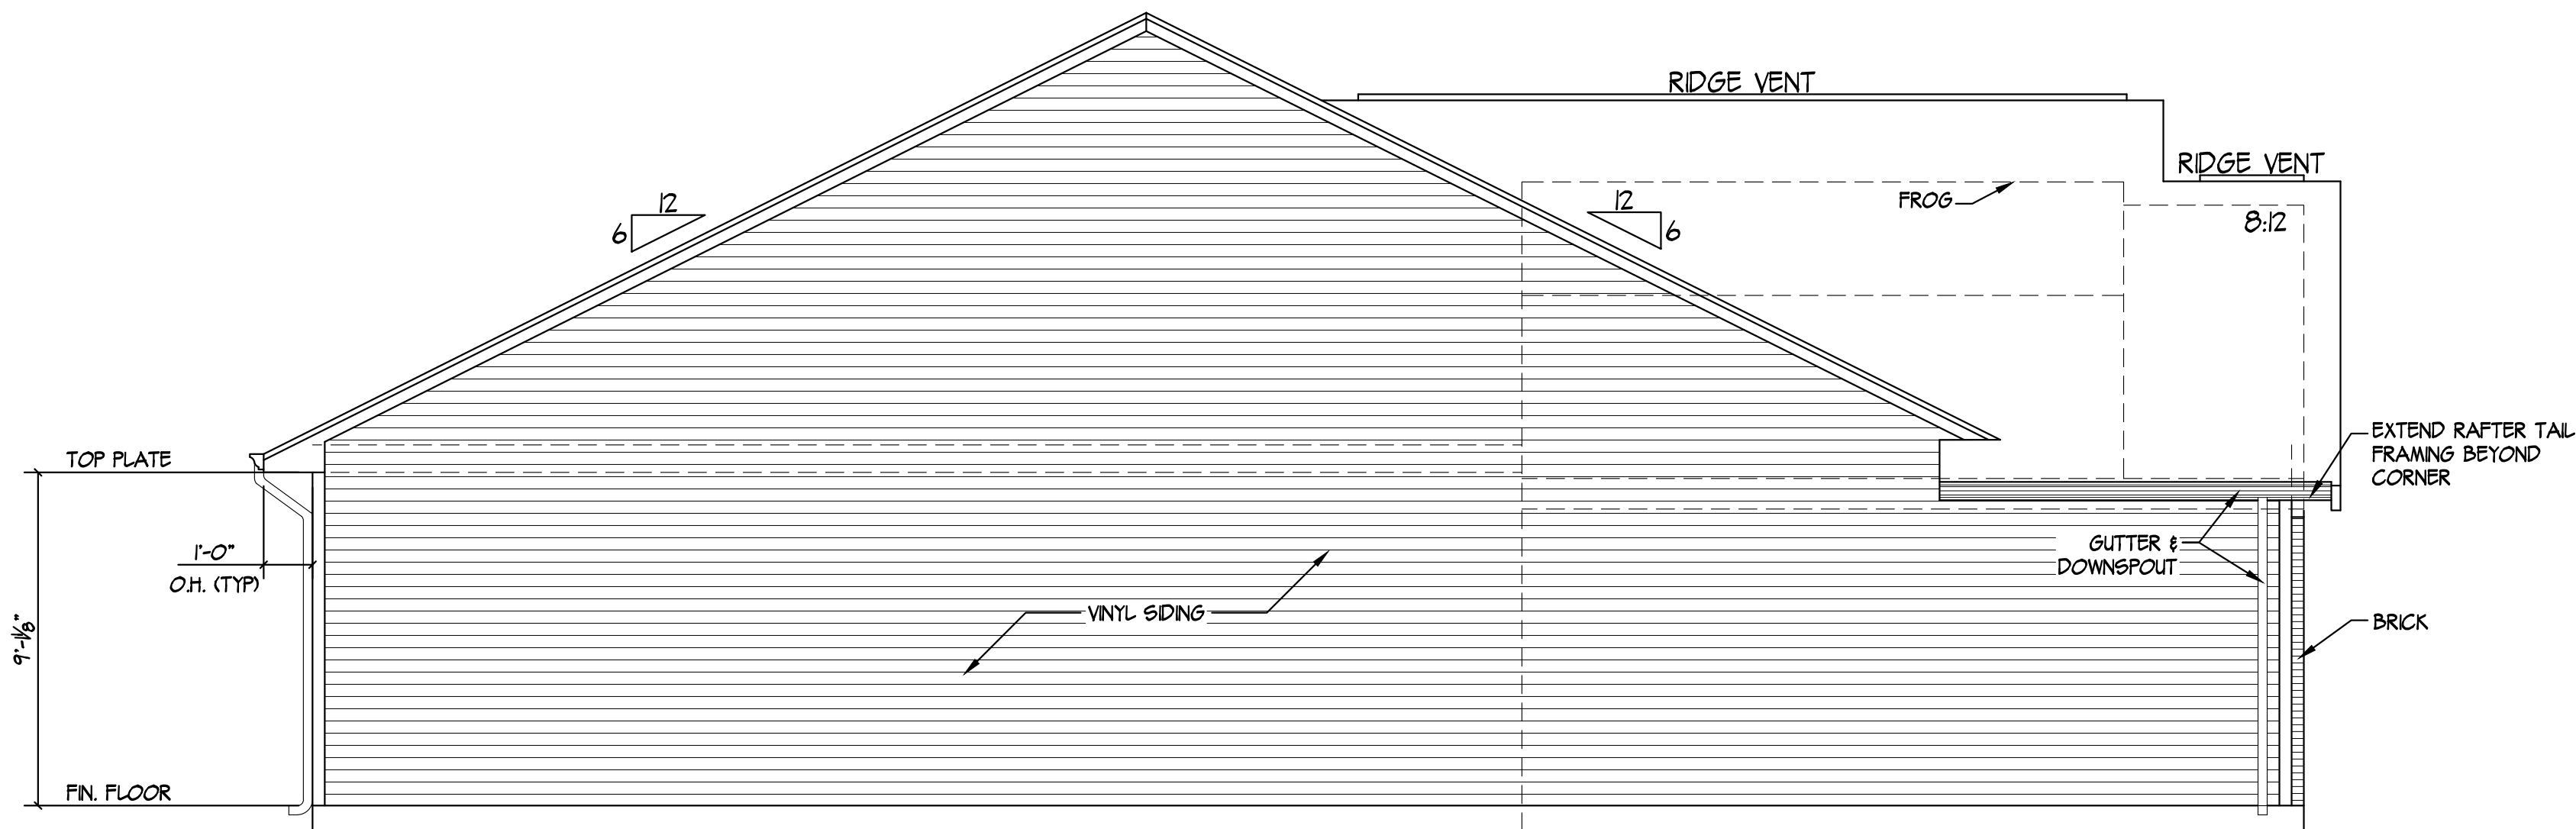

SIDE ELEVATION

JAGOE HOMES

3624 WATHENS CROSSING
OWENSBORO, KENTUCKY 42301
(270) 684-0639

DATE: February 06, 2025	
LAST SAVED BY: Terry.Gebhard	
LAST SAVED: Thu, 06 Feb 2025 - 1:07pm	
CREATED: Thu, 19 Jan 2012 - 3:36pm	
FILE NAME: SUMMIT AS OF 020725.dwg	
TIME PLOTTED: Thu, 06 Feb 2025 - 1:40pm	
REVISION:	
PDR#183	DATE:03/28/12
PDR#424	DATE:03/24/15
PDR# 594	DATE:02/28/17
PDR#730	DATE:10/12/18
PDR#000	DATE:00/00/00

CUSTOMER NAME RESIDENCE

STREET ADDRESS

CITY, STATE & ZIP


LOT & SUBDIVISION

SUMMIT

RIGHT & LEFT BONUS C

Sheet Number


A2.1

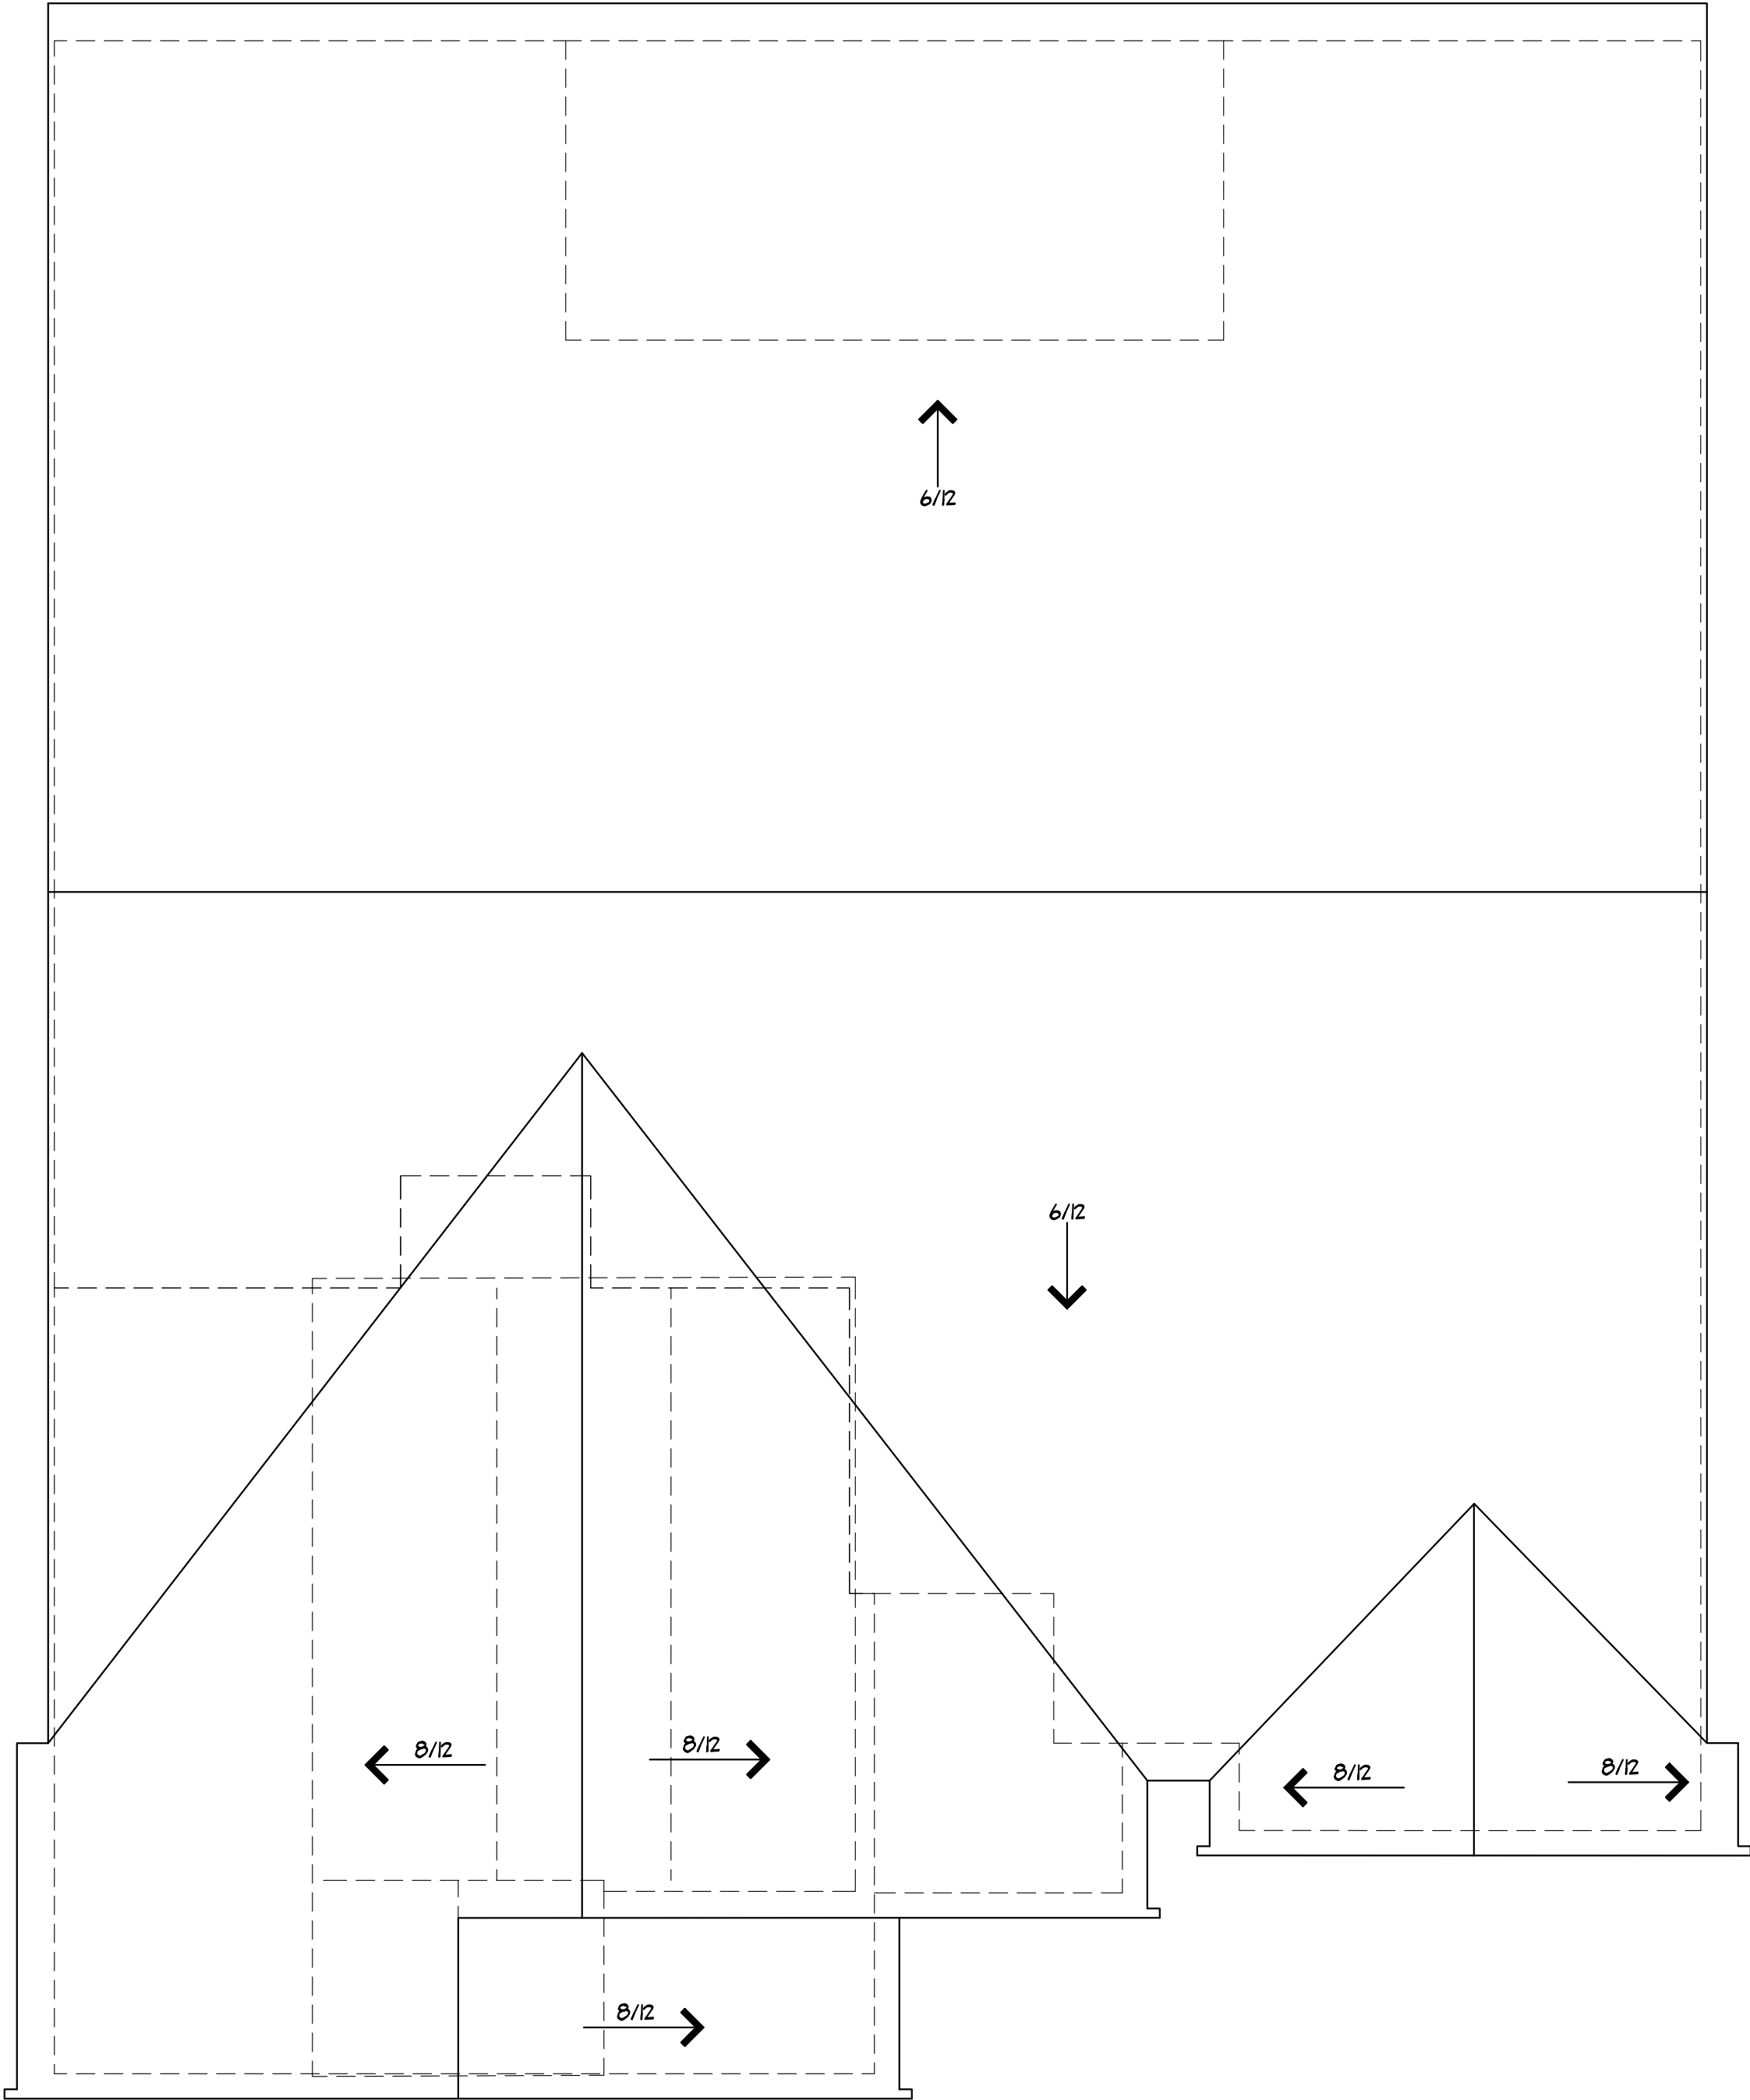

DATE : February 06, 2025	
LAST SAVED BY: Terry.Gebhard	
LAST SAVED: Thu, 06 Feb 2025 - 1:07pm	
CREATED: Thu, 19 Jan 2012 - 3:36pm	
FILE NAME: SUMMIT AS OF 020725.dwg	
TIME PLOTTED: Thu, 06 Feb 2025 - 1:40pm	
REVISION:	
PDR#183	DATE:03/28/12
PDR#424	DATE:03/24/15
PDR# 594	DATE:02/28/17
PDR#730	DATE:10/12/18
PDR#000	DATE:00/00/00

CUSTOMER NAME RESIDENCE	
STREET ADDRESS	
CITY, STATE & ZIP	
LOT & SUBDIVISION	
SUMMIT	
ROOF BONUS C	

Sheet Number
A4.1

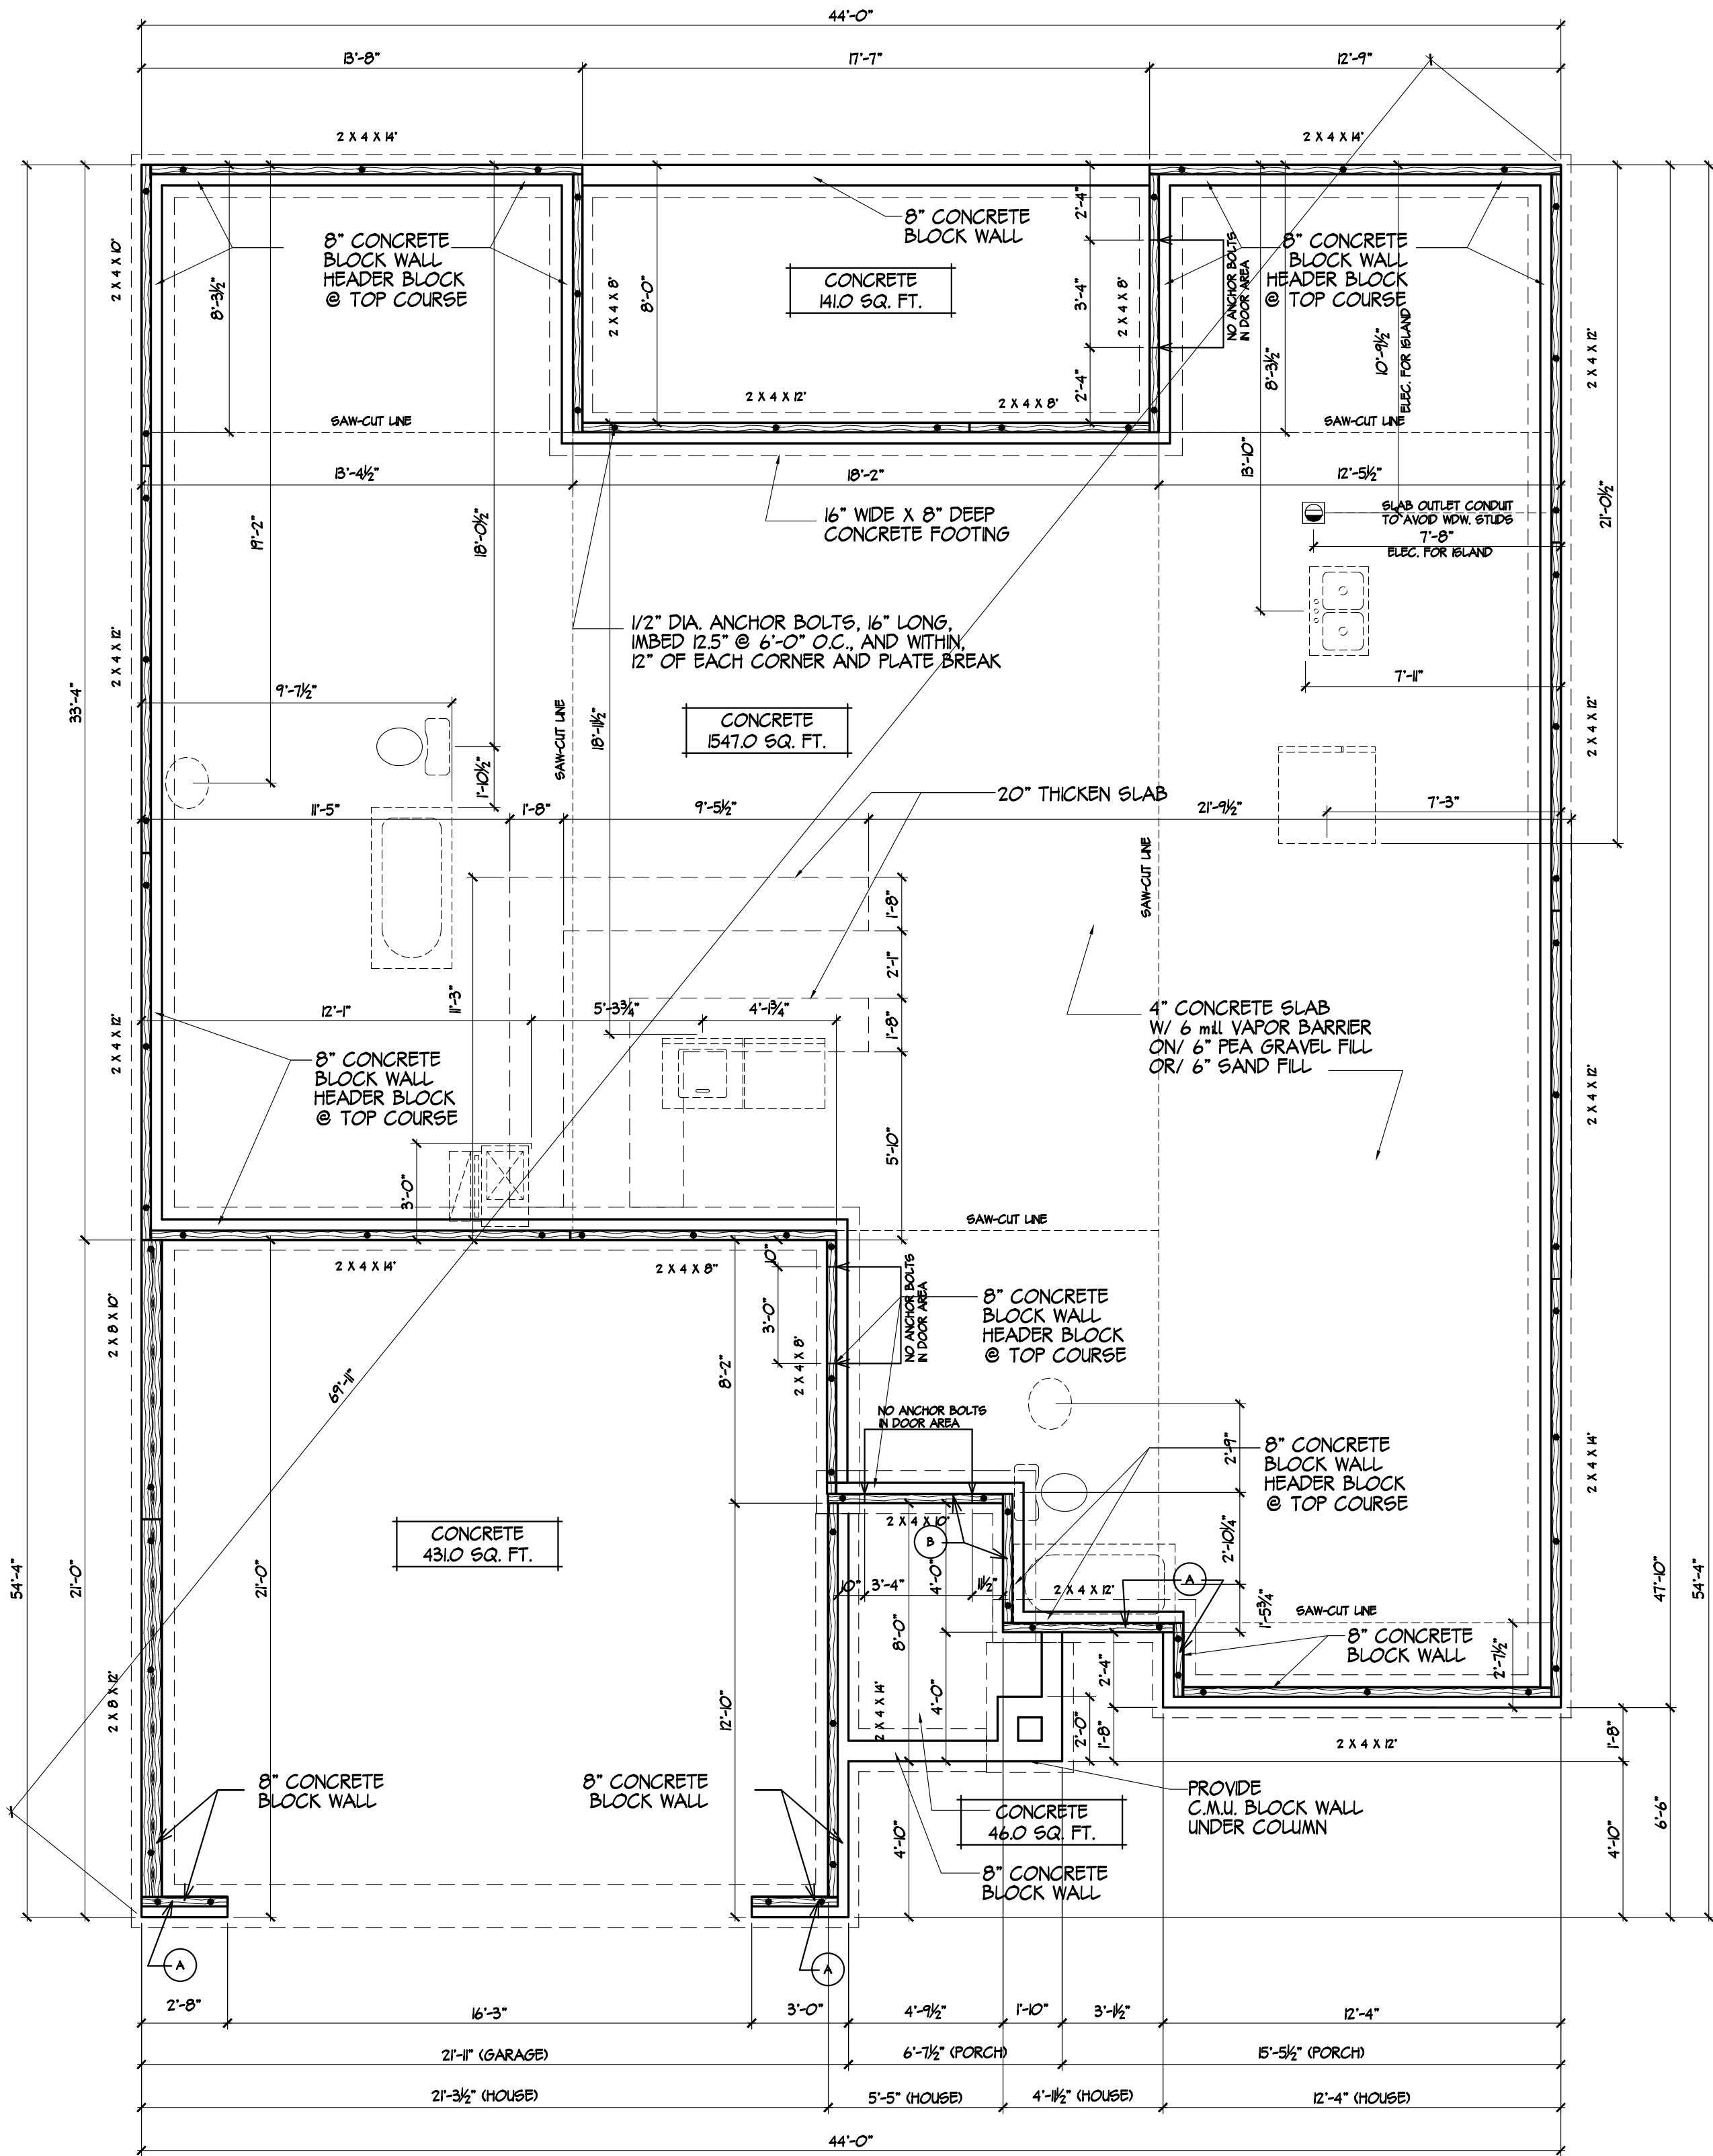

DATE: February 06, 2025	
LAST SAVED BY: Terry.Gebhard	
LAST SAVED: Thu, 06 Feb 2025 - 1:07pm	
CREATED: Thu, 19 Jan 2012 - 3:36pm	
FILE NAME: SUMMIT AS OF 020725.dwg	
TIME PLOTTED: Thu, 06 Feb 2025 - 1:41pm	
REVISION:	
PDR#183	DATE:03/28/12
PDR#424	DATE:03/24/15
PDR# 594	DATE:02/28/17
PDR#730	DATE:10/12/18
PDR#000	DATE:00/00/00

CUSTOMER NAME RESIDENCE

STREET ADDRESS
CITY, STATE & ZIP
LOT & SUBDIVISION
SUMMIT

FOUNDATION BONUS C1

Sheet Number

S 1.1