




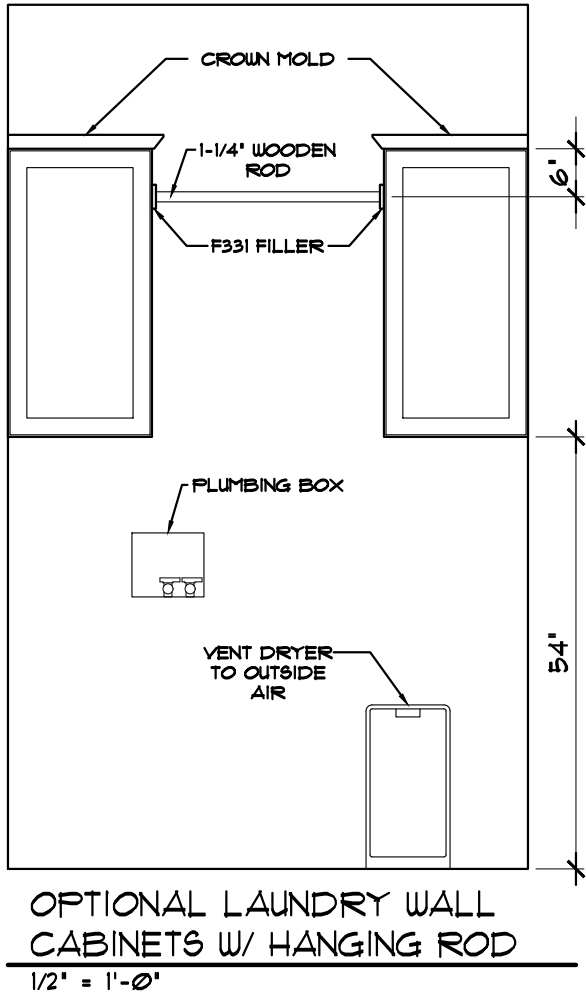


OPTIONAL LAUNDRY WALL
CABINETS W/ HANGING ROD
1/2" = 1'-0"

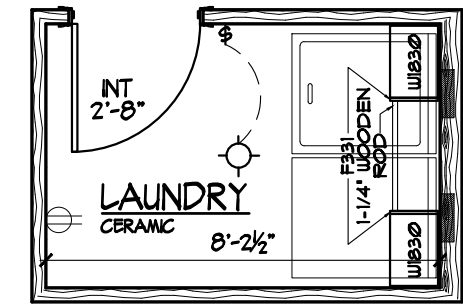

OPTIONAL LAUNDRY WALL
CABINETS W/ HANGING ROD
1/4" = 1'-0"

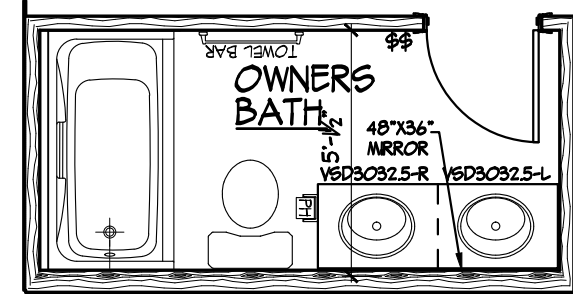


DOUBLE BOWL OPTION
SCALE: 1/4" = 1'-0"

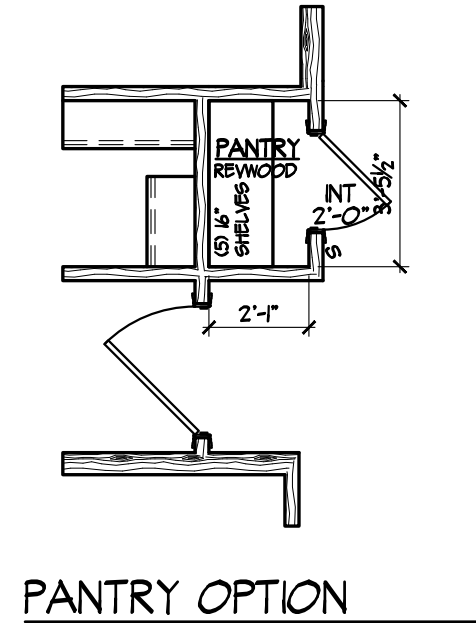

PANTRY OPTION

FLOOR AREA

1323.0 SQ. FT. LIVING-BRICK
391.0 SQ. FT. GARAGE-FRAME
74.0 SQ. FT. PORCH
1788.0 SQ. FT.

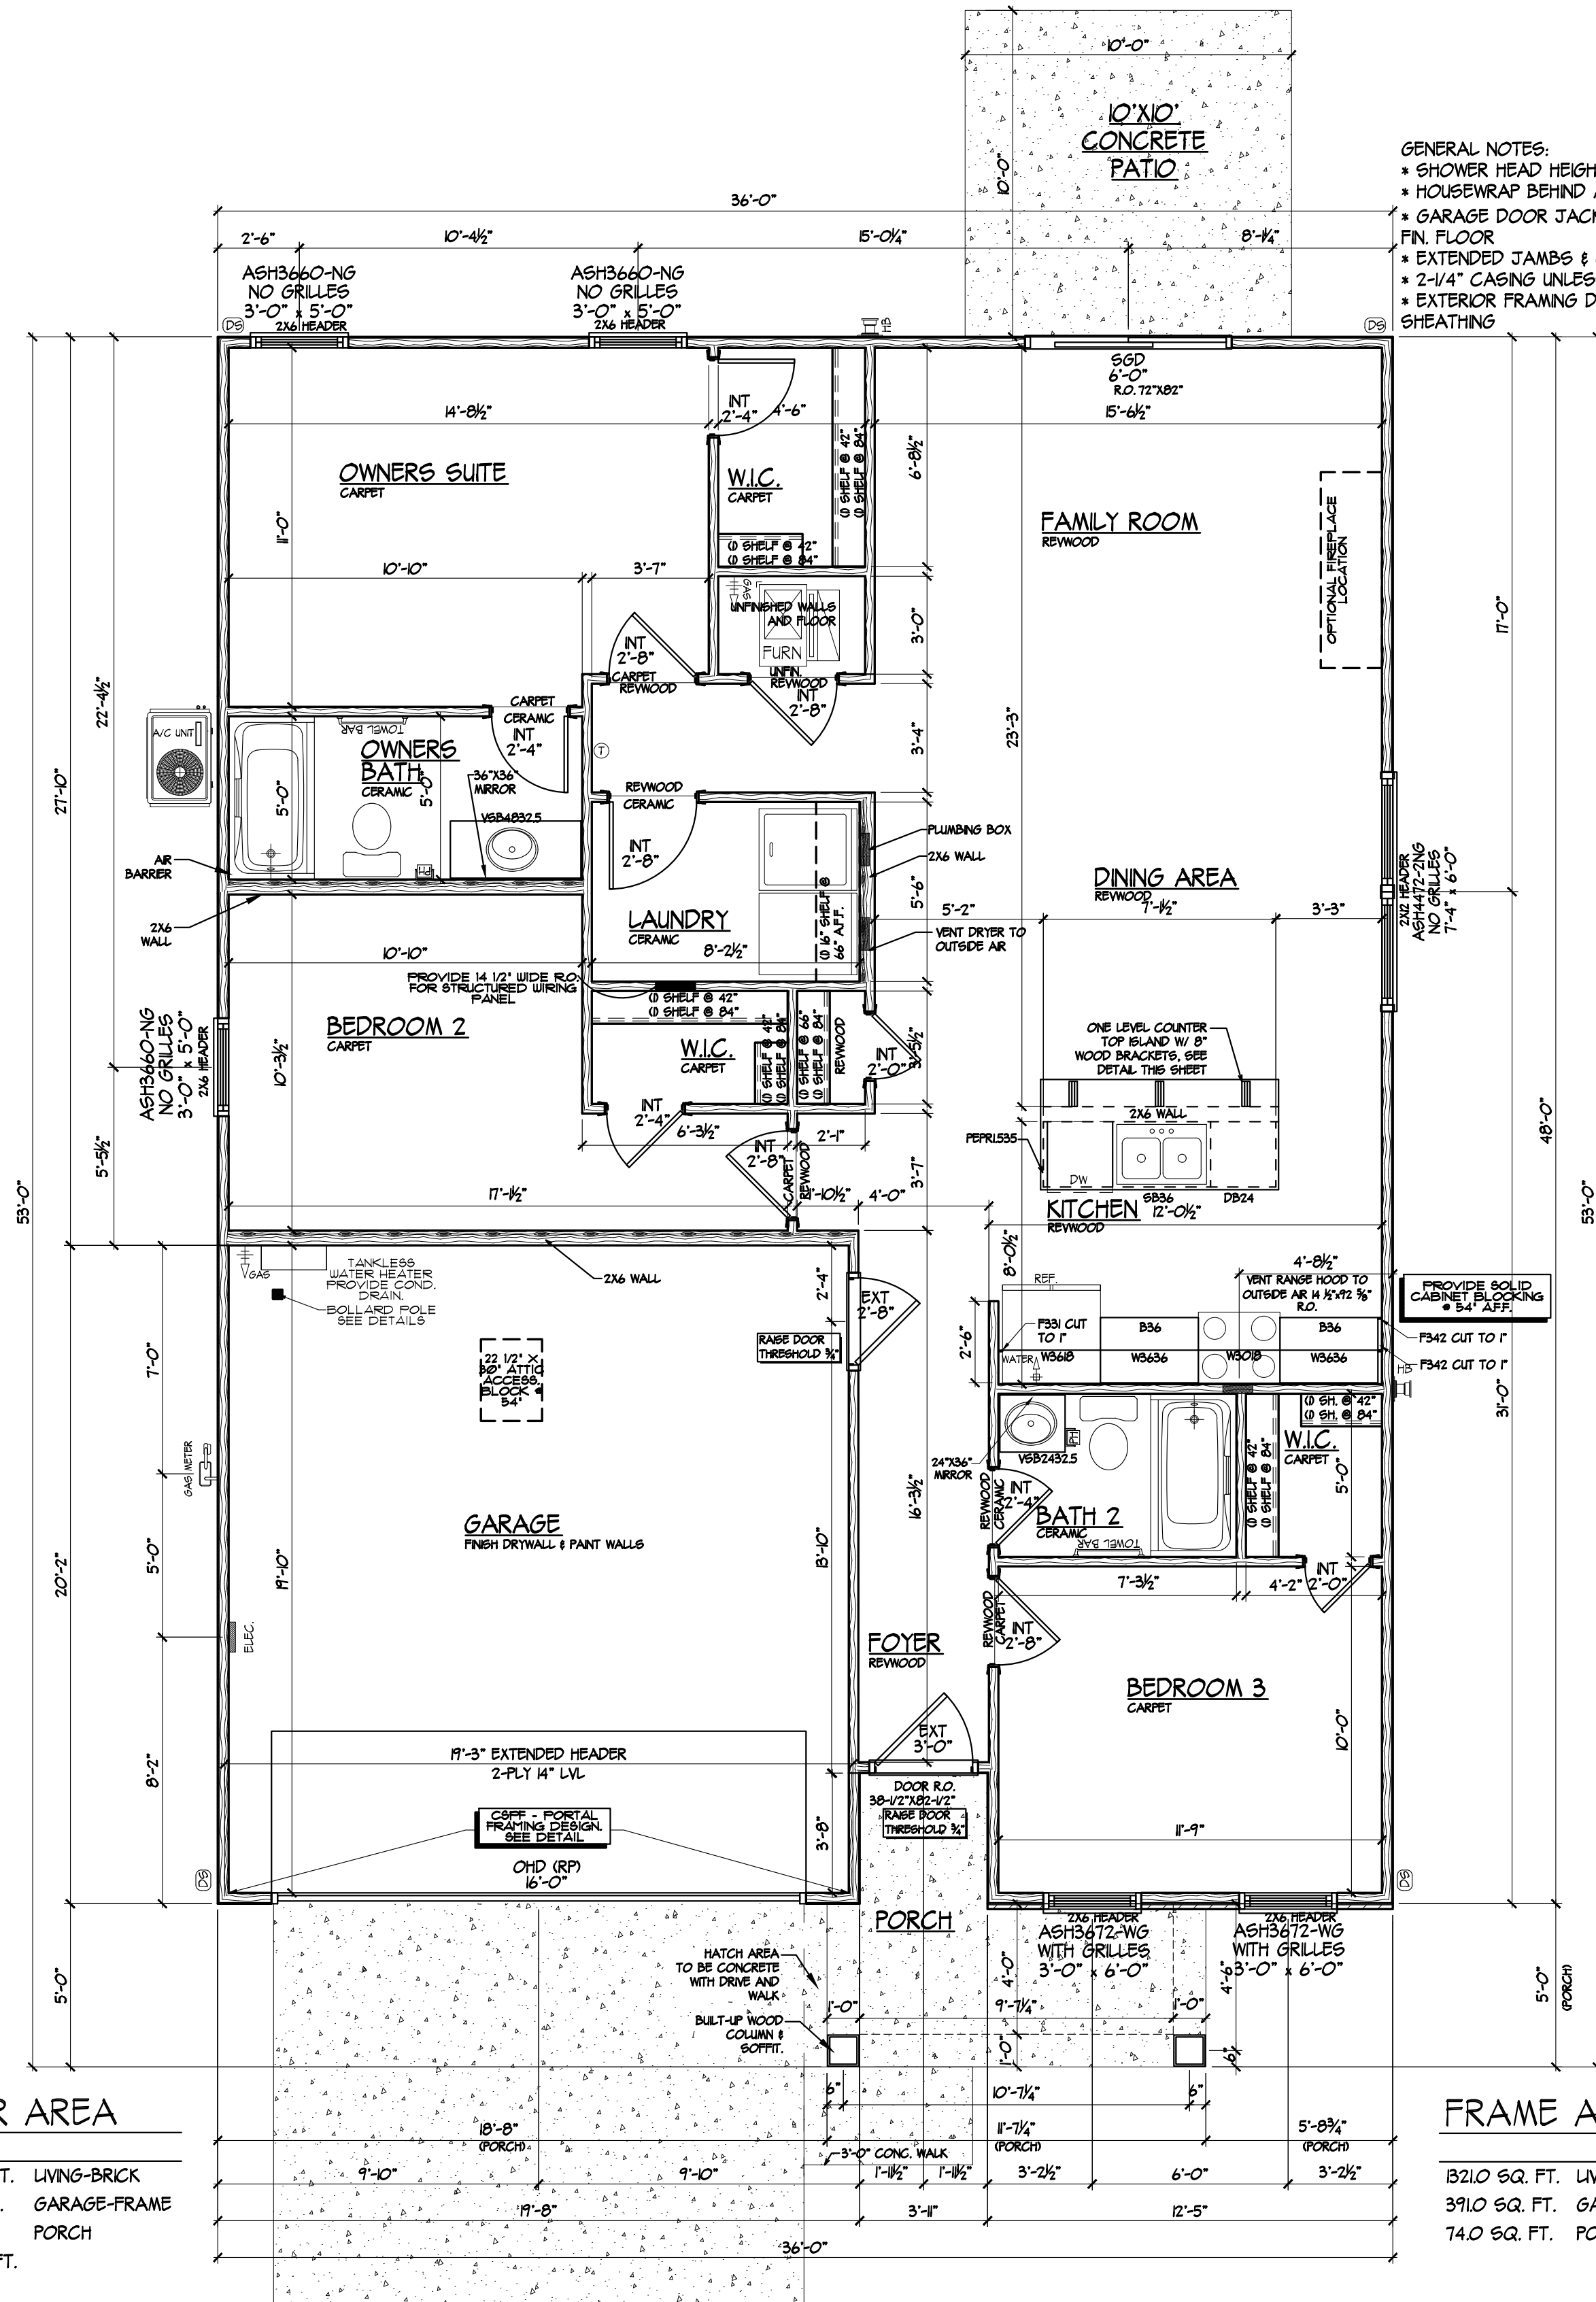

FRAME AREA

1321.0 SQ. FT. LIVING-FRAME
391.0 SQ. FT. GARAGE-FRAME
74.0 SQ. FT. PORCH

- GENERAL NOTES:
- * SHOWER HEAD HEIGHT ROUGH-IN TO BE 84" A.F.F.
 - * HOUSEWRAP BEHIND ALL TUBS & SHOWERS.
 - * GARAGE DOOR JACKS TO BE MIN. 1/8", MAX. 1/4" OFF FIN. FLOOR
 - * EXTENDED JAMBS & CASING.
 - * 2-1/4" CASING UNLESS NOTED OTHERWISE ON PLAN
 - * EXTERIOR FRAMING DIMENSIONS INCLUDE 1/2" FOR SHEATHING

CUSTOMER NAME RESIDENCE

STREET
CITY

LOT #
LEONARDO

MAIN FLOOR PLAN C ELEV.

Sheet Number

C.2.1.1





DATE:	December 11, 2024
LAST SAVED BY:	Kayleigh.Edge
LAST SAVED:	Wed, 11 Dec 2024 - 11:16am
CREATED:	Wed, 29 Aug 2012 - 9:56am
FILE NAME:	LEONARDO 121124.dwg
TIME PLOTTED:	Wed, 11 Dec 2024 - 11:35am
REVISION:	
PDR#A.B.	DATE:08/15/13
PDR#298	DATE:10/14/13
PDR#730	DATE:7/11/18
PDR#832	DATE:01/07/19
PDR#000	DATE:00/00/00

JAGOE HOMES

3624 WATHENS CROSSING
OWENSBORO, KENTUCKY 42301
(270) 684-0639

Technical drawing of a cedar column wrap. The drawing shows a cross-section of a column with a 1x10 cedar wrap. The wrap is positioned around a 2x4 treated post. The dimensions are as follows:

- Horizontal dimensions: 7 3/4" (width of the wrap) and 9 1/4" (total width including the post).
- Vertical dimensions: 7 3/4" (height of the wrap) and 9 1/4" (total height including the post).
- Labels: "TREATED 2x4" for the post, "1x10 CEDAR" for the wrap, and "NOTE: CEDAR COLUMN WRAP TO BE POSITIONED SO THAT END GRAIN IS NOT VISIBLE FROM THE STREET APPROACH. RIPPING 1x ON THE SIDES WILL BE REQUIRED."

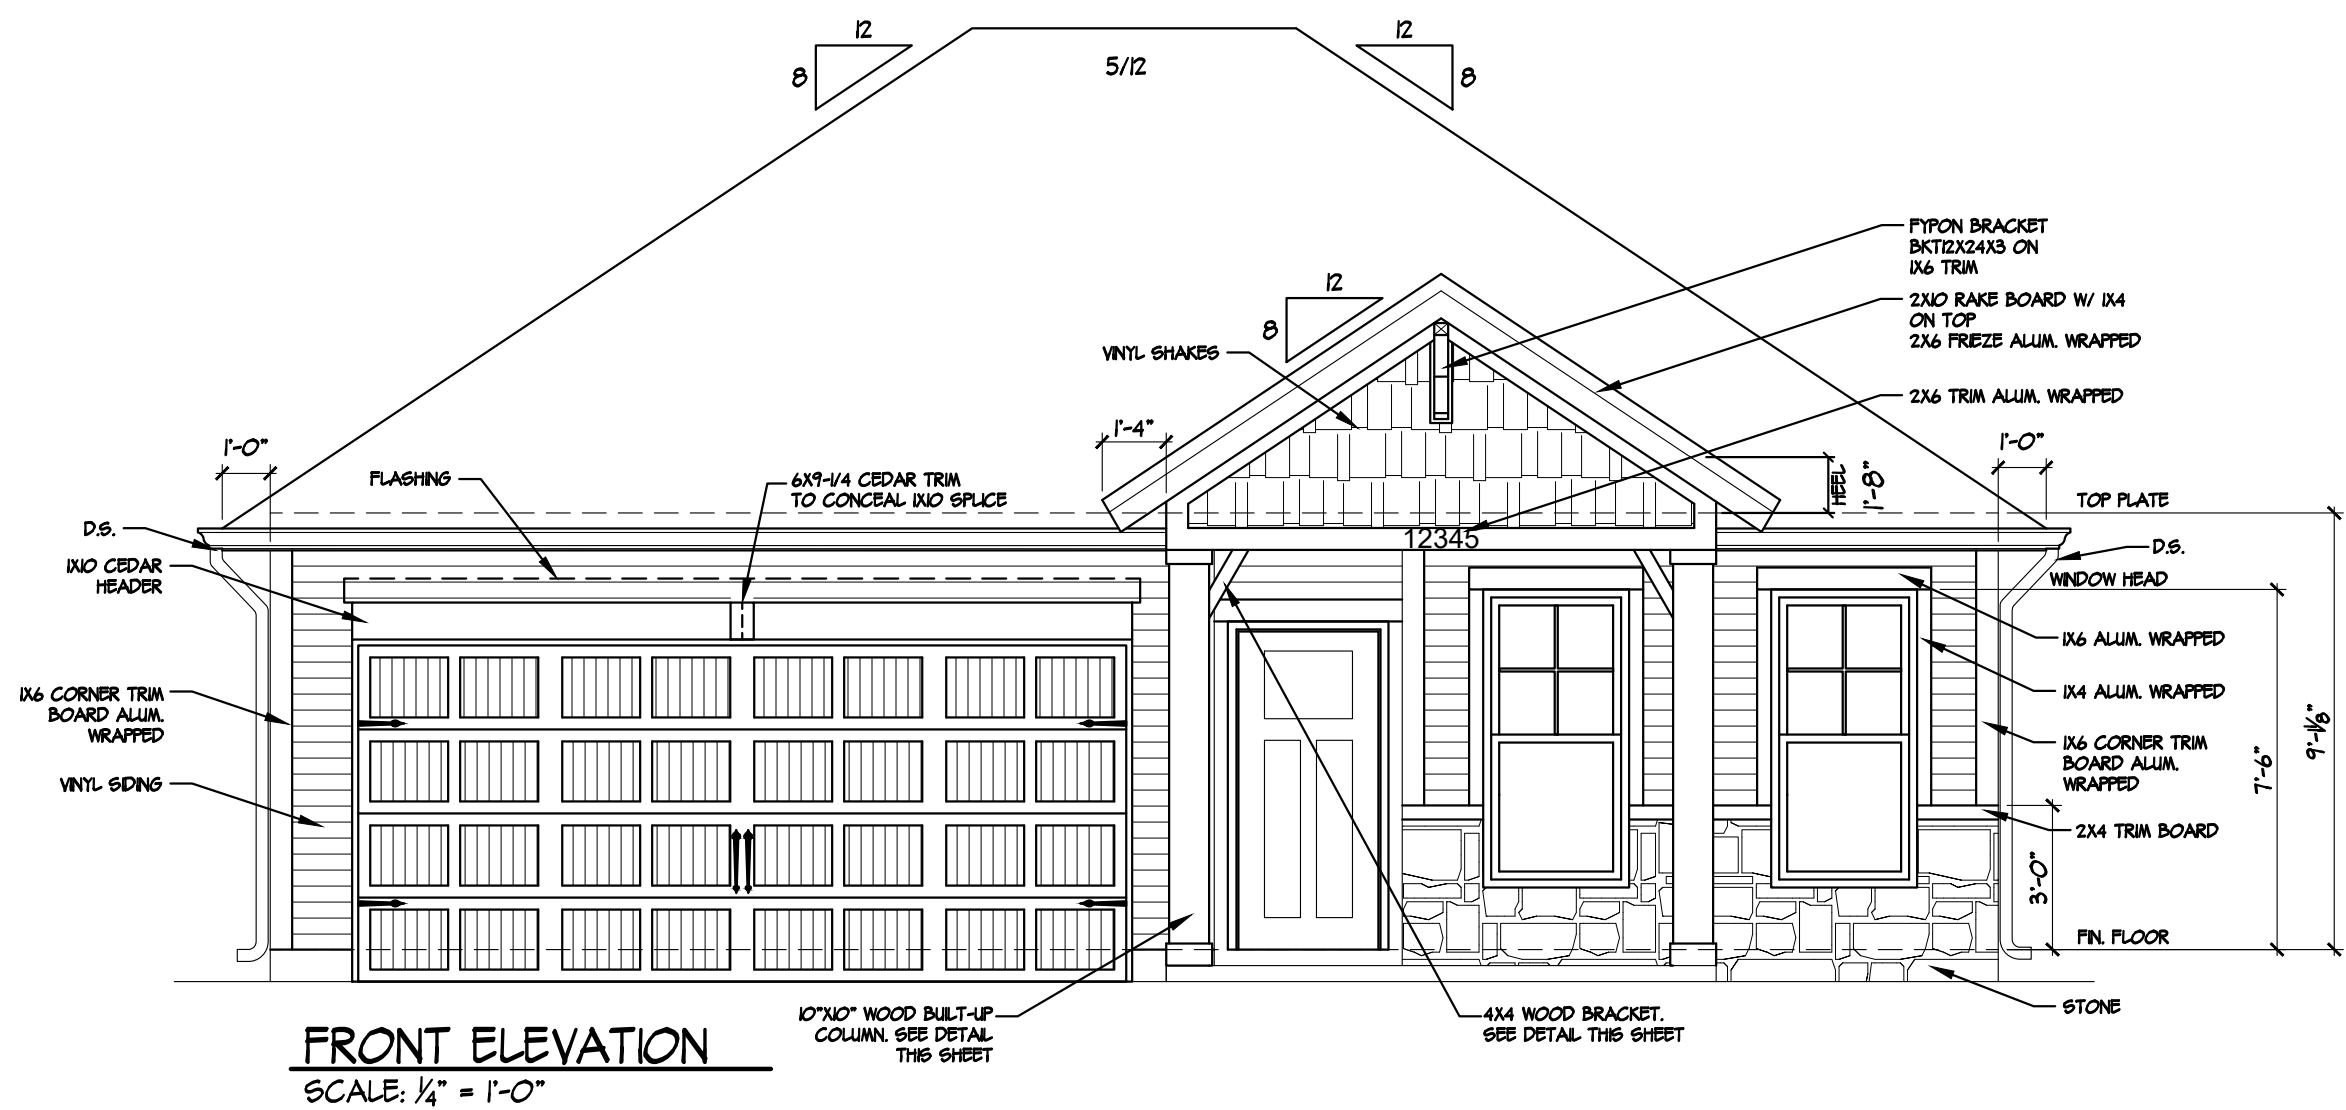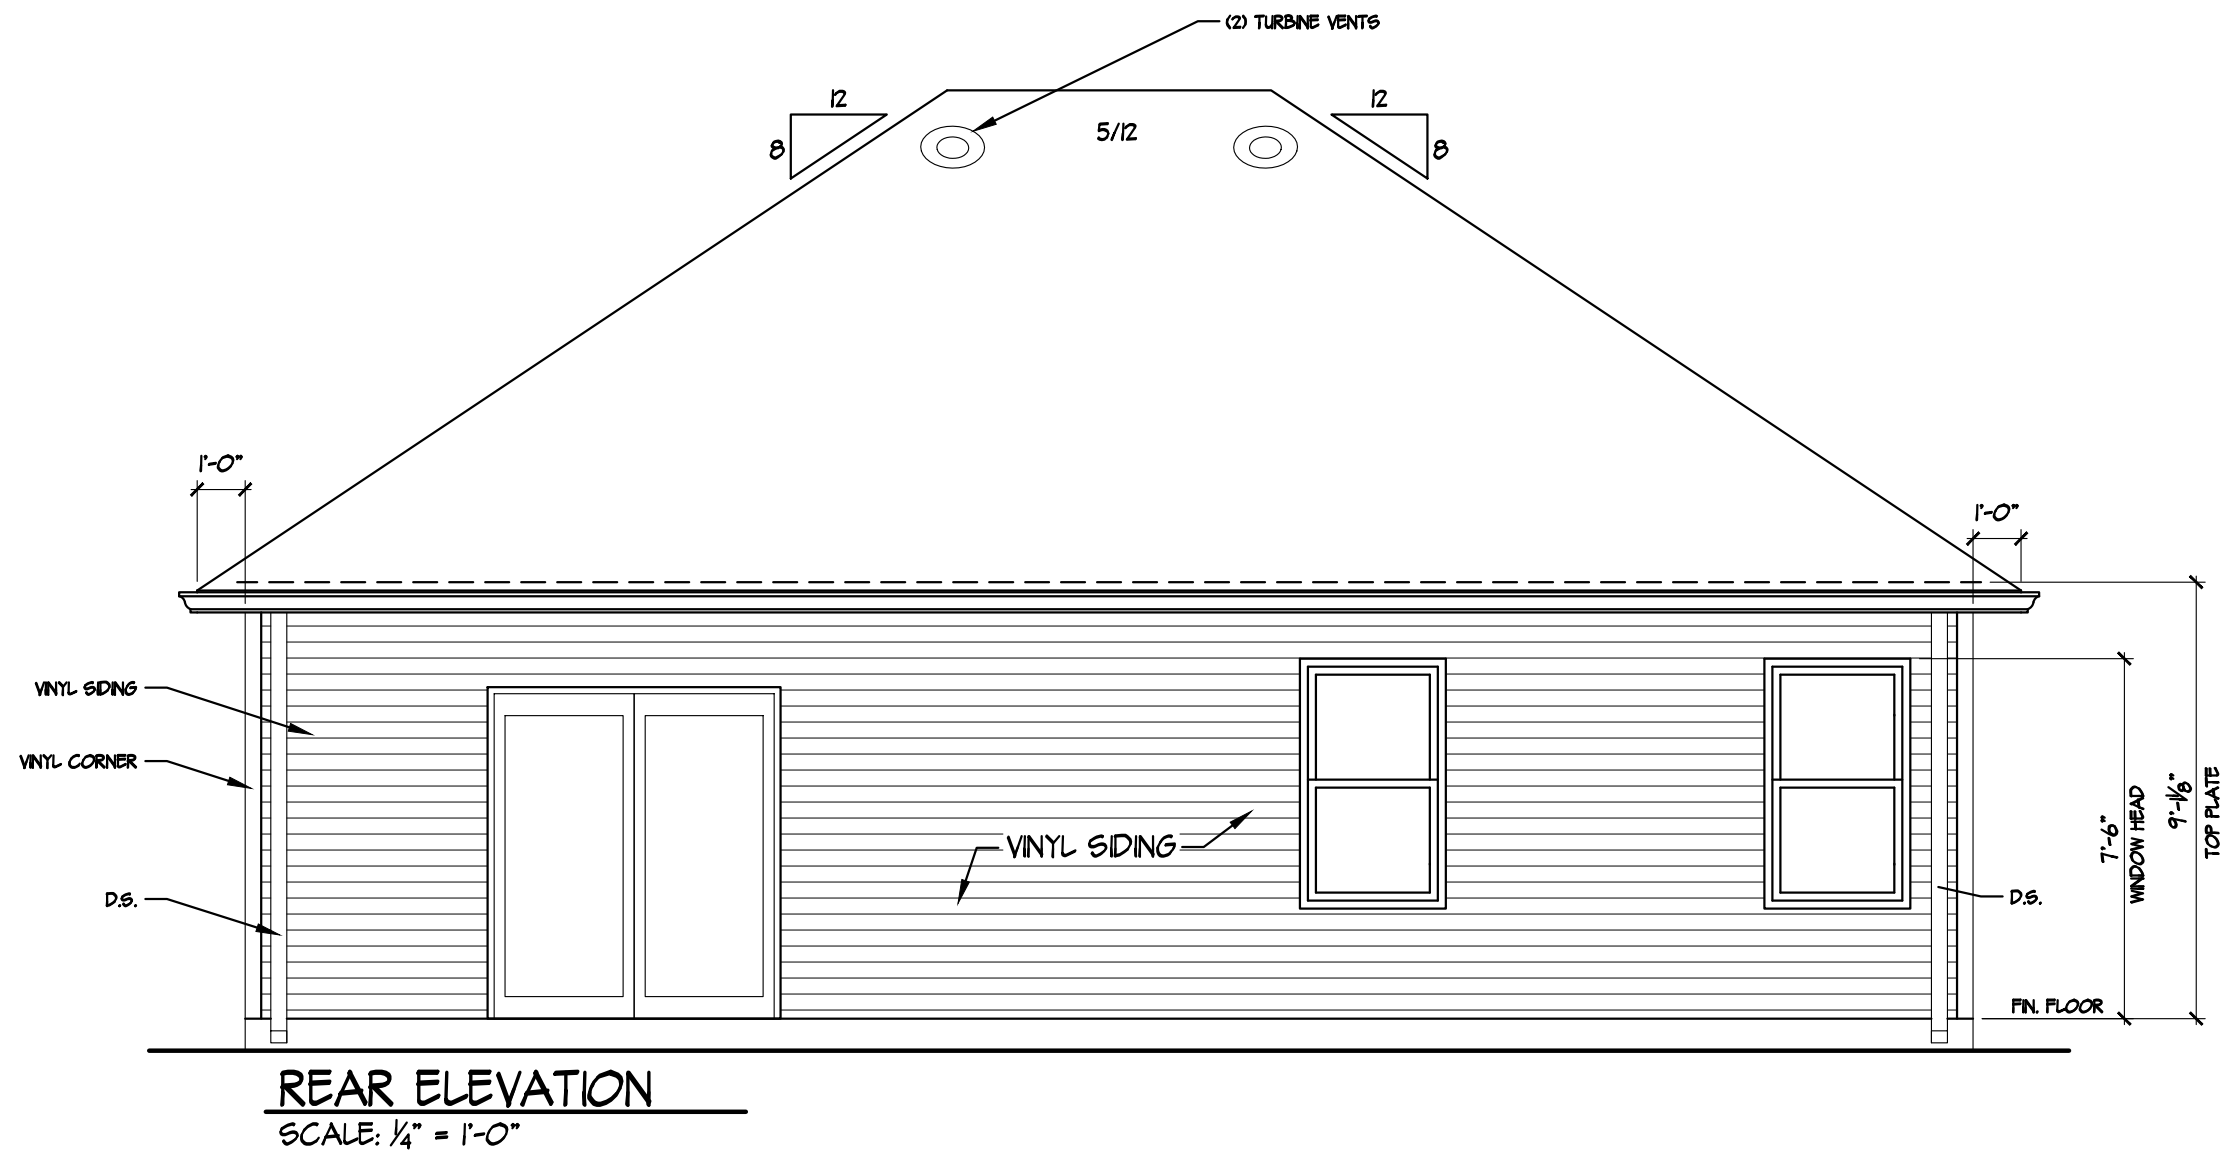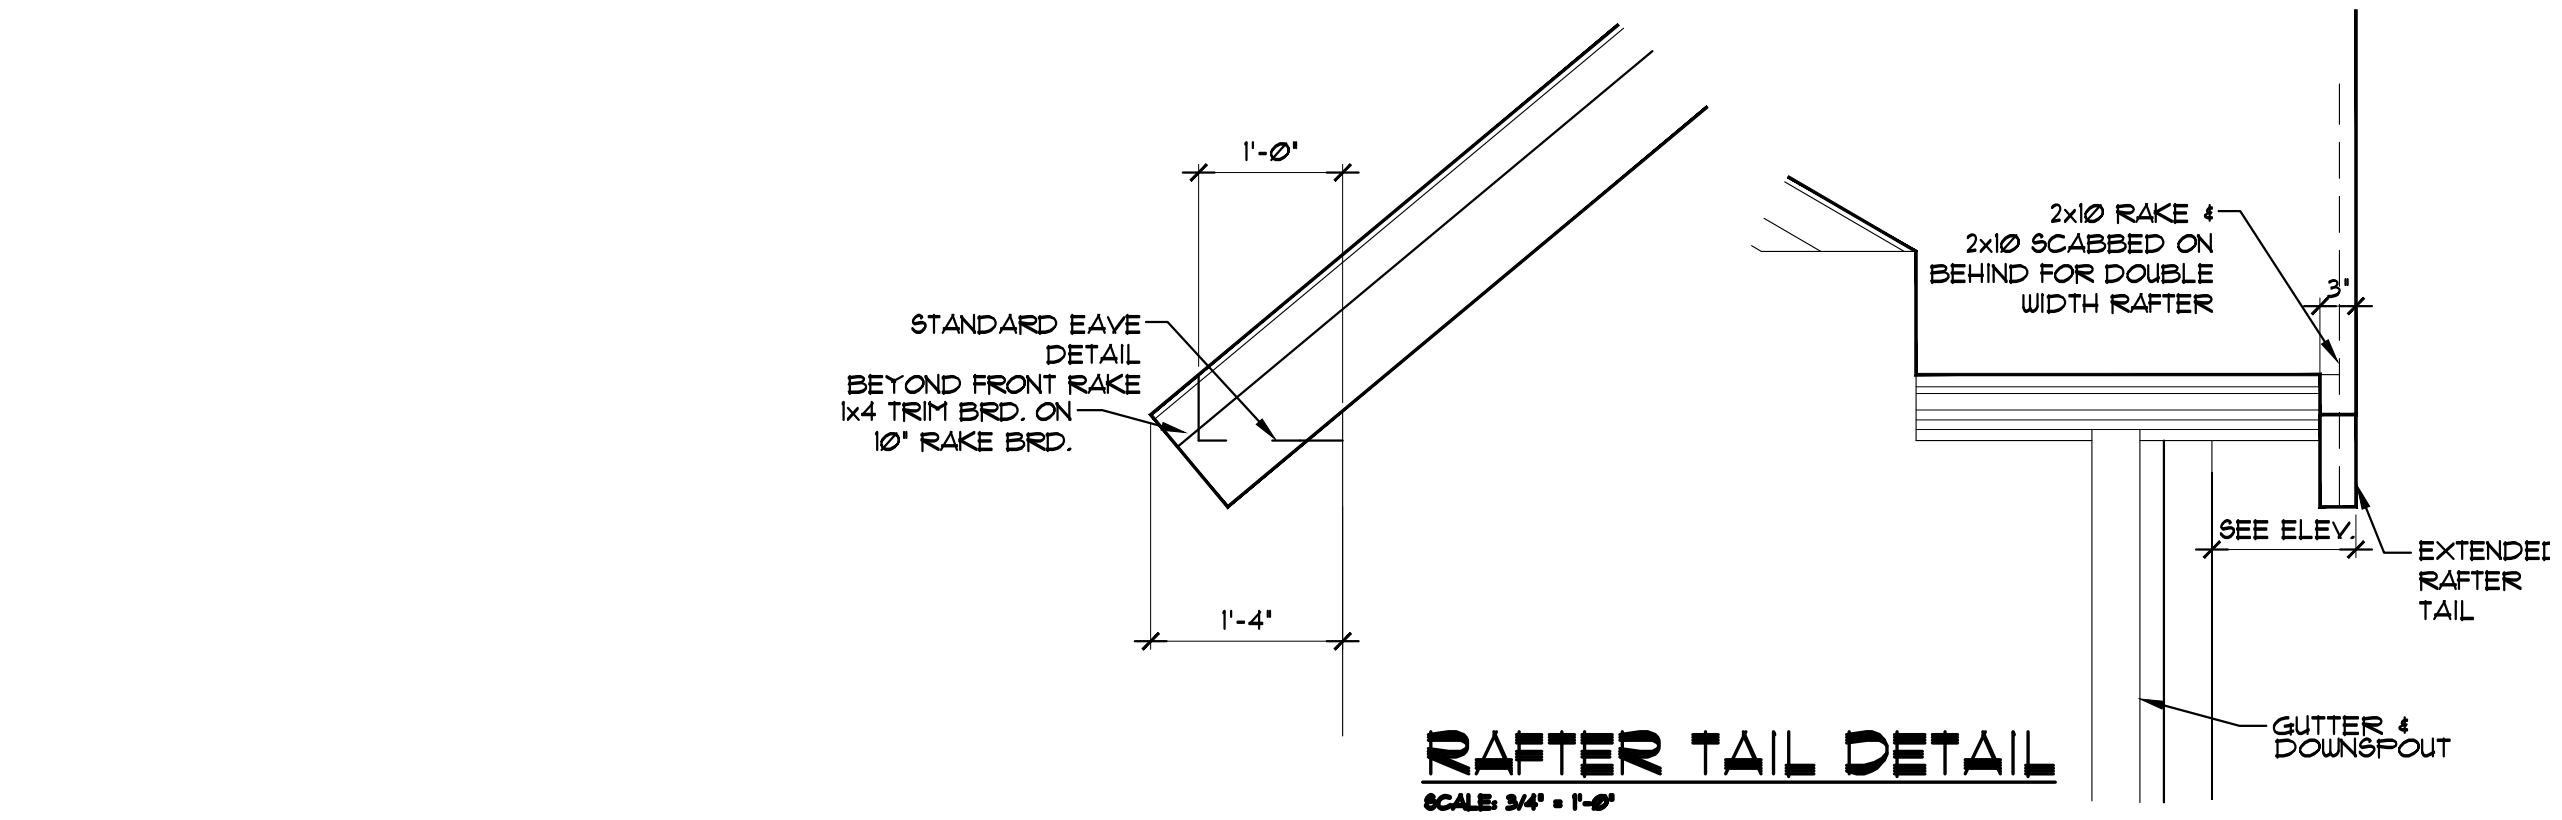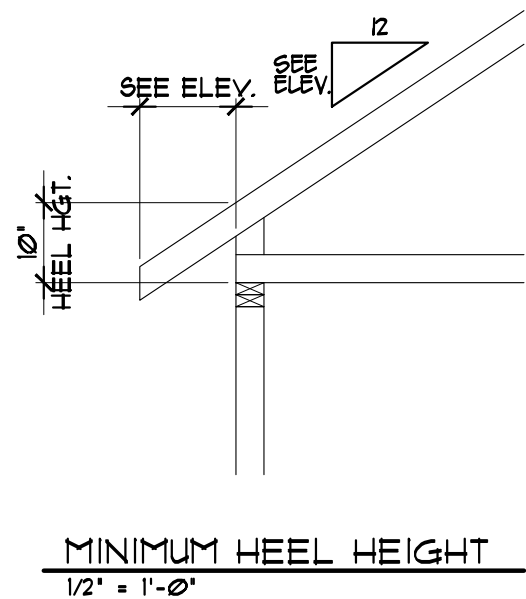

JACQUE
HOMES

3624 WATHENS CROSSING
OWENSBORO, KENTUCKY 42301
(270) 684-0639



DATE:	
December 11, 2024	
LAST SAVED BY:	
Kayleigh.Edge	
LAST SAVED:	
Wed, 11 Dec 2024 - 11:16am	
CREATED:	
Wed, 29 Aug 2012 - 9:56am	
FILE NAME:	
LEONARDO 121124.dwg	
TIME PLOTTED:	
Wed, 11 Dec 2024 - 11:37am	
REVISION:	
PDR#A.B	DATE:08/15/13
PDR#298	DATE:10/14/13
PDR#730	DATE:7/11/18
PDR#832	DATE:01/07/19
PDR#000	DATE:00/00/00

CUSTOMER NAME RESIDENCE
STREET
CITY
LOT #
LEONARDO
FRONT & REAR ELEVATIONS C

Sheet Number

C.5.1.1

© 2001 Jagoe Homes, Inc. Unauthorized use of this plan is in violation of the U.S. Copyright Act, Title 17 of the U.S. Code. Reported square footage is approximate and based upon Architectural Design. Area and actual dimensions may vary according to construction methods. Dimensions used on floor plans are framing dimensions. Municipality requirements regarding size of foundation block may affect framing dimensions shown on plans. Brochures as shown by artist's renditions may not show all standards and options. Specifications may change without notice. Variations may occur by neighborhood, lot location, and home series. Not all plan brochures may be placed on every lot. Location of residence on lot shall be determined by Jagoe Homes Inc.

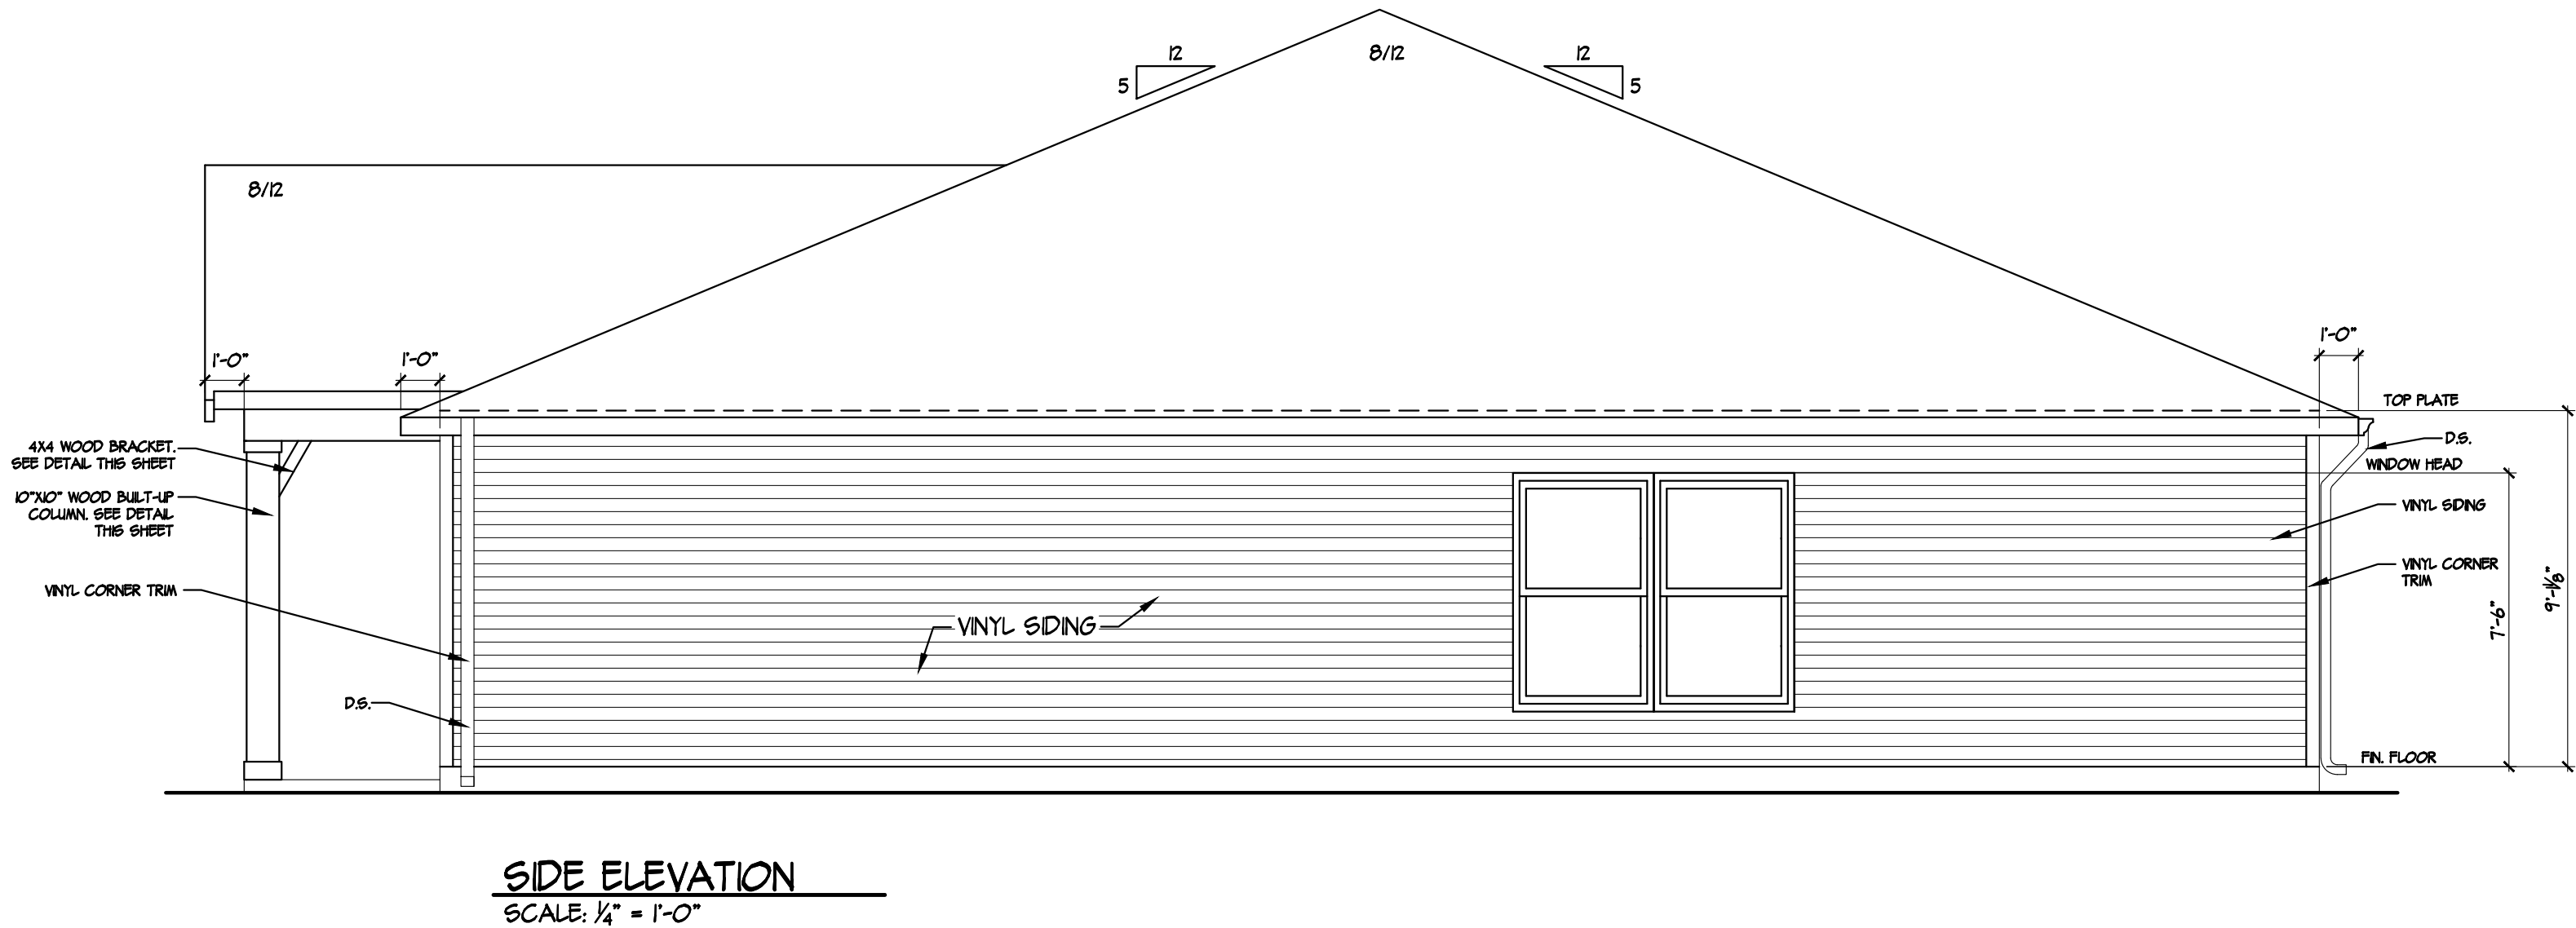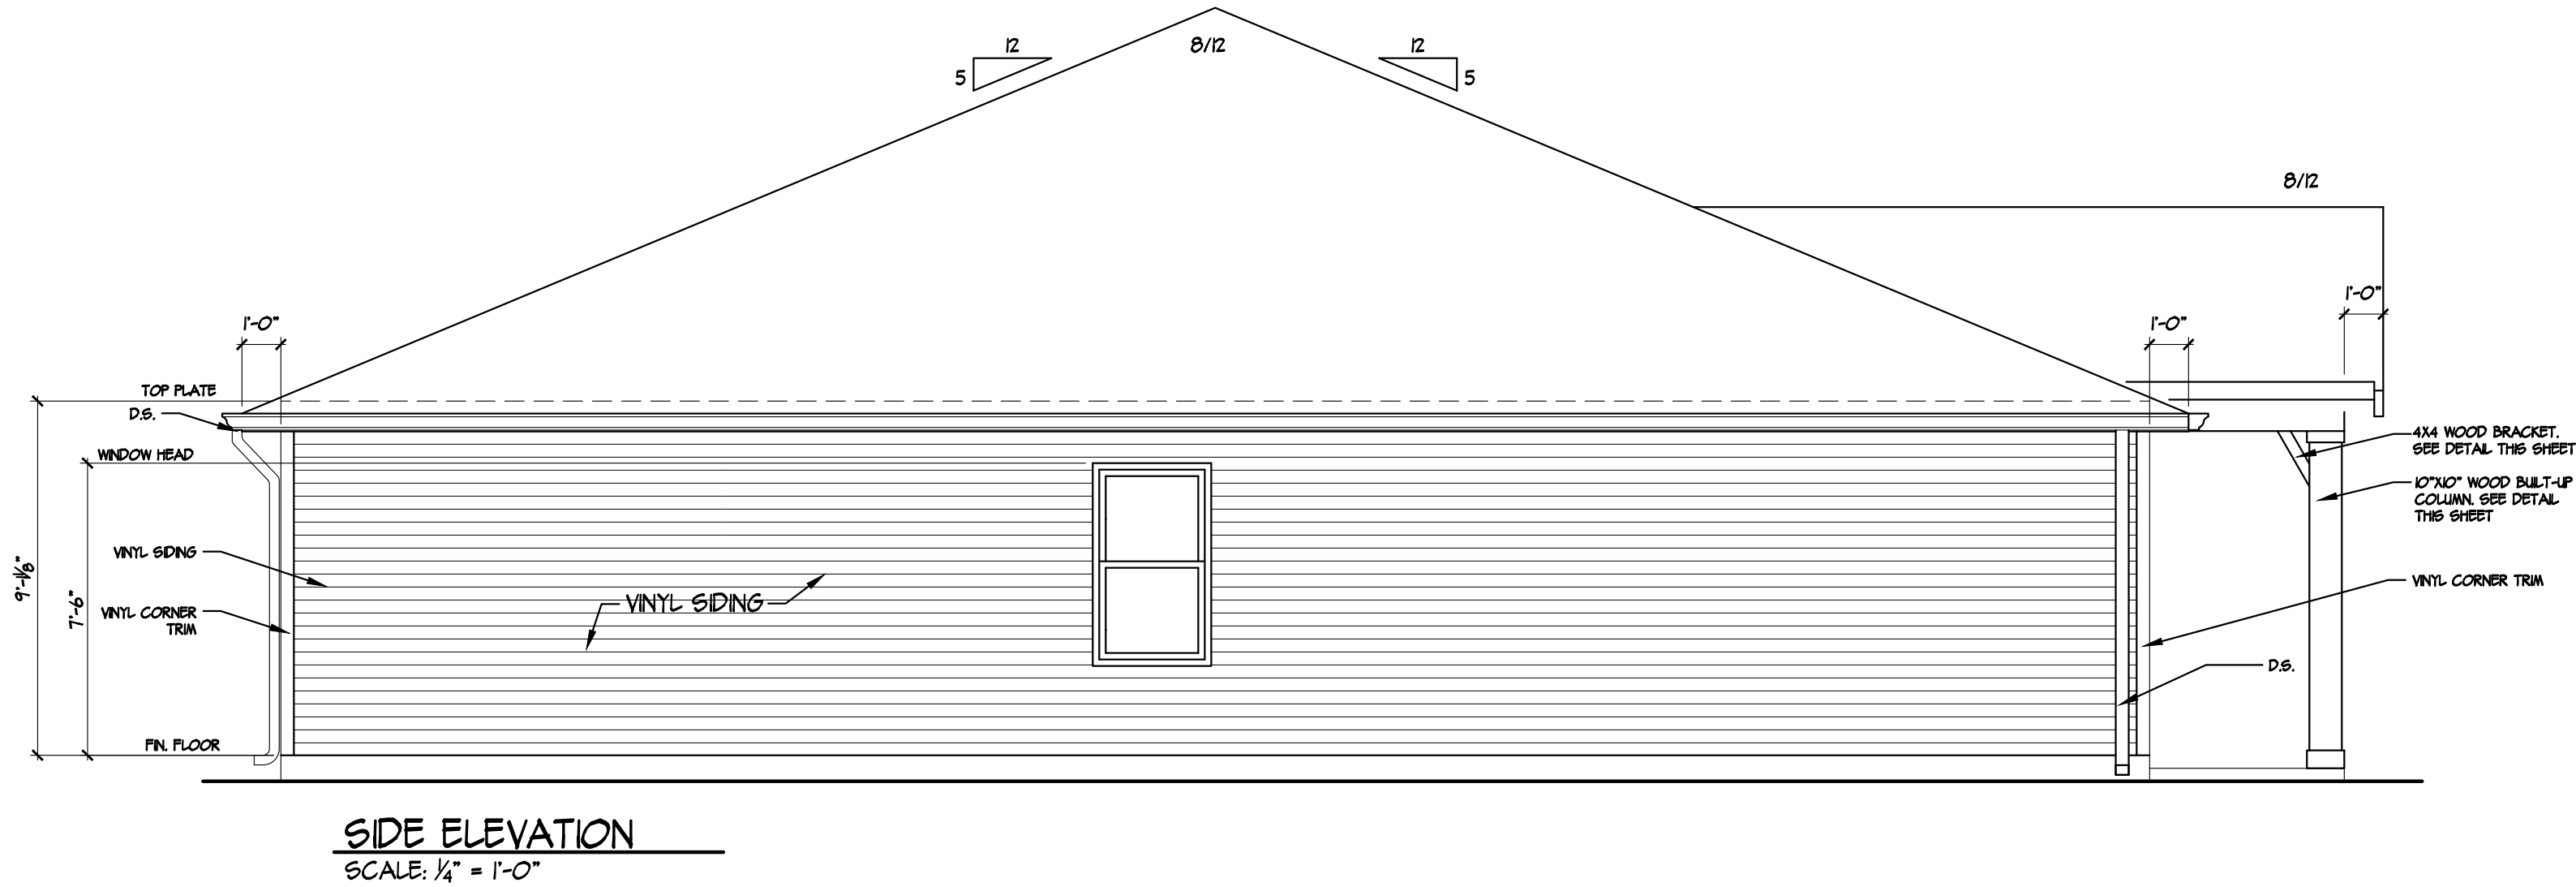

JAGOE

HOMES

3624 WATHENS CROSSING
OWENSBORO, KENTUCKY 42301
(270) 684-0639

DATE: December 11, 2024	
LAST SAVED BY: Kayleigh.Edge	
LAST SAVED: Wed, 11 Dec 2024 - 11:16am	
CREATED: Wed, 29 Aug 2012 - 9:56am	
FILE NAME: LEONARDO 121124.dwg	
TIME PLOTTED: Wed, 11 Dec 2024 - 11:37am	
REVISION: PDR#A.B. DATE:08/15/13 PDR#298 DATE:10/14/13 PDR#730 DATE:7/11/18 PDR#832 DATE:01/07/19 PDR#000 DATE:00/00/00	

CUSTOMER NAME RESIDENCE

STREET
CITY


LOT #
LEONARDO

RIGHT & LEFT ELEVATIONS C


Sheet Number

C.6.1.1

Ⓜ SYMBOL = LED DOWNLIGHTS

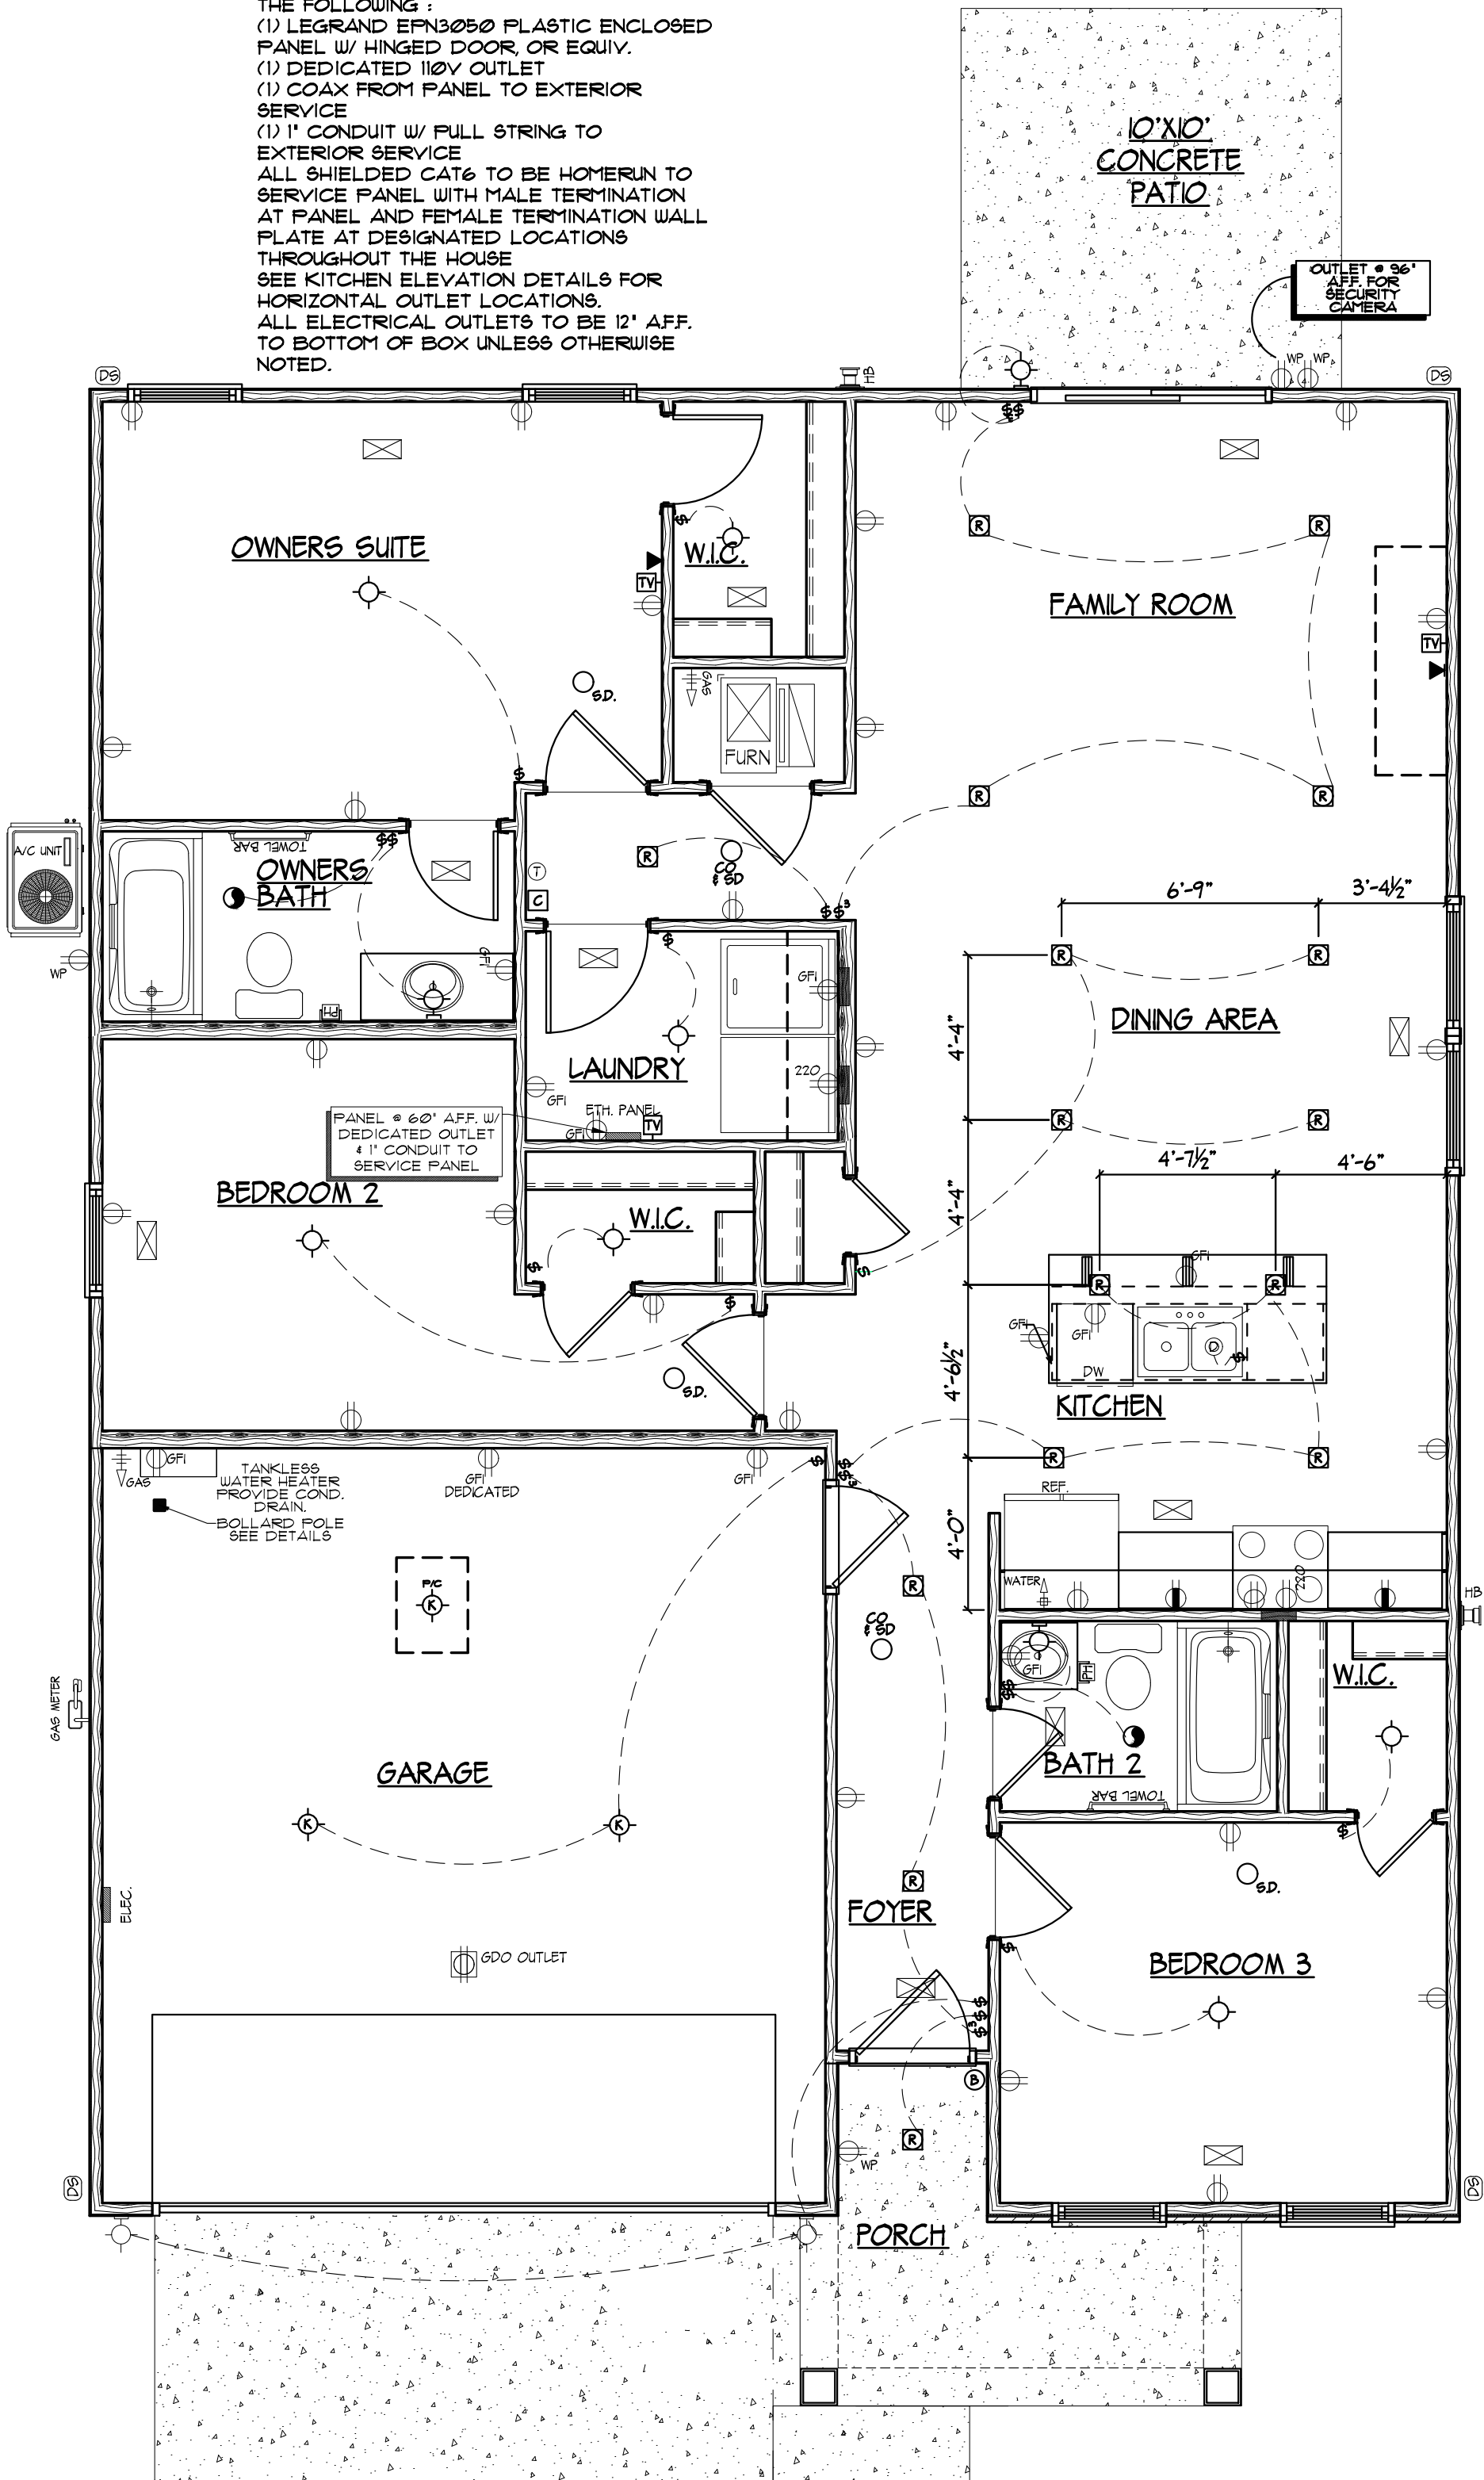

ELECTRICAL LEGEND	
SYMBOL	DESCRIPTION
	WIRE SWITCHING & CONNECTIONS
	DUPLEX OUTLET (GROUNDED TYPE)
	DOUBLE DUPLEX OUTLET (QUAD) (GROUNDED TYPE)
	GROUND FAULT INTERRUPTER DUPLEX OUTLET
	WEATHER PROOF GFI DUPLEX OUTLET
	WALL SWITCH CONTROLLED DUPLEX OUTLET
	ABOVE COUNTER LOCATION **SEE NOTE BELOW**
	E9902.6 KITCHEN RECEPTACLES, 125-VOLT, SINGLE PHASE, E- AND 20-AMPERE RECEPTACLES THAT SERVE COUNTERTOP SURFACES SHALL HAVE GROUND-FAULT CIRCUIT-INTERRUPTER PROTECTION FOR PERSONNEL.
	FLUSH FLOOR DUPLEX OUTLET (OWNER VERIFY)
	220 VOLT OUTLET OR CONNECTION
	CEILING MOUNTED OUTLET FOR GARAGE DOOR
	SINGLE POLE WALL SWITCH
	3-WAY WALL SWITCH
	SINGLE POLE WALL SWITCH WITH DIMMER
	3-WAY WALL SWITCH WITH DIMMER
	OVER / UNDER SWITCH
	CEILING MOUNTED LIGHT FIXTURE
	CEILING MOUNTED KEYLESS LIGHT FIXTURE
	CEILING MOUNT KEYLESS LIGHT W/ PULL CHAIN
	WALL BRACKET MOUNTED LIGHT FIXTURE
	HANGING CEILING MOUNTED LIGHT FIXTURE
	RECESSED DIRECTIONAL CEILING LIGHT FIXTURE (EYEBALL)
	LED DOWNLIGHT
	RECESSED LIGHT FOR WET AREA
	CEILING MOUNTED FAN - EXHAUST
	CEILING MOUNTED FAN AND LIGHT
	UNDER CABINET LIGHTING
	STARWAY STEP LIGHTS
	EXTERIOR CAST ALUMINUM FLOOD LIGHTS
	'8ATCO' 7" LED LIGHT
	'8ATCO' 9" LED LIGHT
	TELEPHONE OUTLET
	TELEVISION ANTENNA / CABLE OUTLET
	CAT 6 OUTLET
	120 VOLT ELECTRICAL PANEL
	DOOR BELL BUTTON
	DOOR CHIME LOCATION
	THERMOSTAT LOCATION
	SINK GARBAGE DISPOSAL
	SMOKE DETECTOR
	COMBINATION CARBON MONOXIDE & SMOKE DETECTOR
	FAN/LIGHT
	FAN ONLY

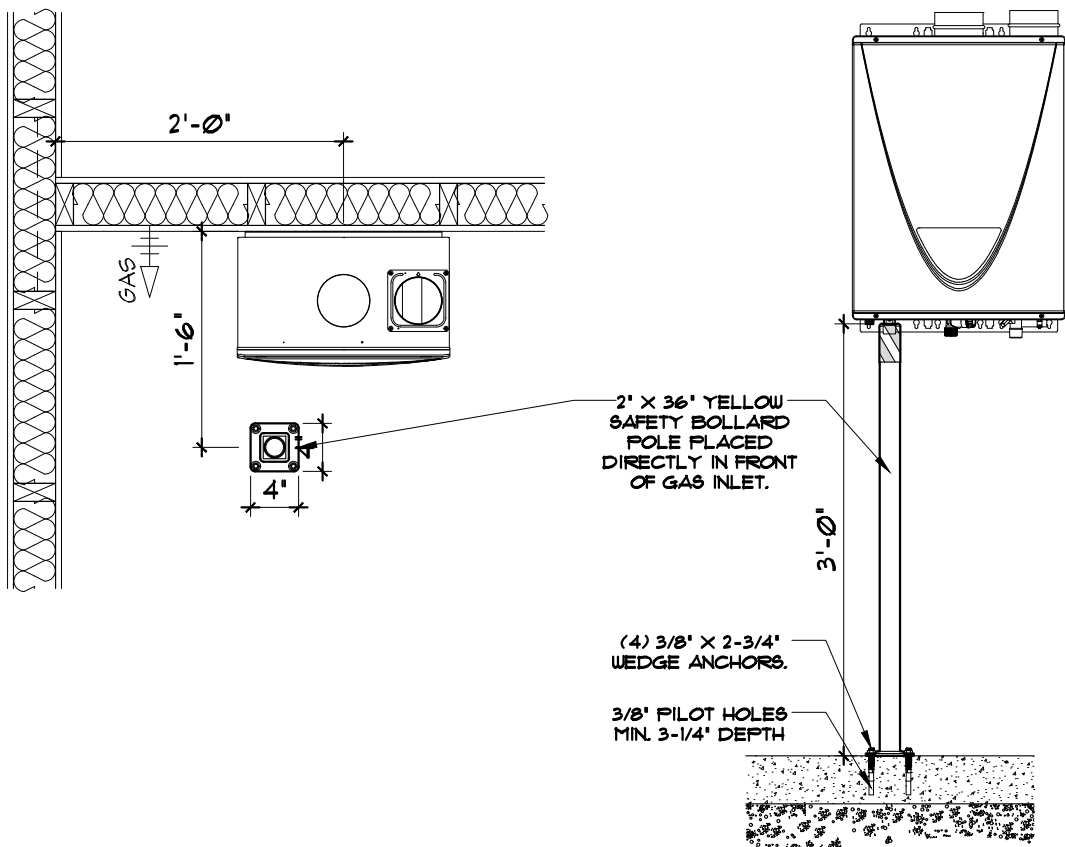

BOLLARD POLE DETAILS

The logo for Jagoe Homes features the word "JAGOE" in a large, bold, black serif font. To the right of "JAGOE", the word "HOMES" is written in a smaller, black, sans-serif font, enclosed within a light gray rounded rectangular box with a thin black border.

3624 WATHENS CROSSING
OWENSBORO, KENTUCKY 42301
(270) 684-0639

DATE:
December 11, 2024

LAST SAVED BY:
Kayleigh.Edge

LAST SAVED:
Wed, 11 Dec 2024 - 11:16am

CREATED:
Wed, 29 Aug 2012 - 9:56am

FILE NAME:
LEONARDO 121124.dwg

TIME PLOTTED:
Wed, 11 Dec 2024 - 11:38am

REVISION:
PDR#A.B. DATE:08/15/13
PDR#298 DATE:10/14/13
PDR#730 DATE:7/11/18
PDR#832 DATE:01/07/19
PDR#000 DATE:00/00/00

CUSTOMER NAME RESIDENCE

STREET
CITY


LOT #

LEONARDO

MAIN FLOOR ELECTRICAL CELEV.

Sheet Number

C.7.1.1

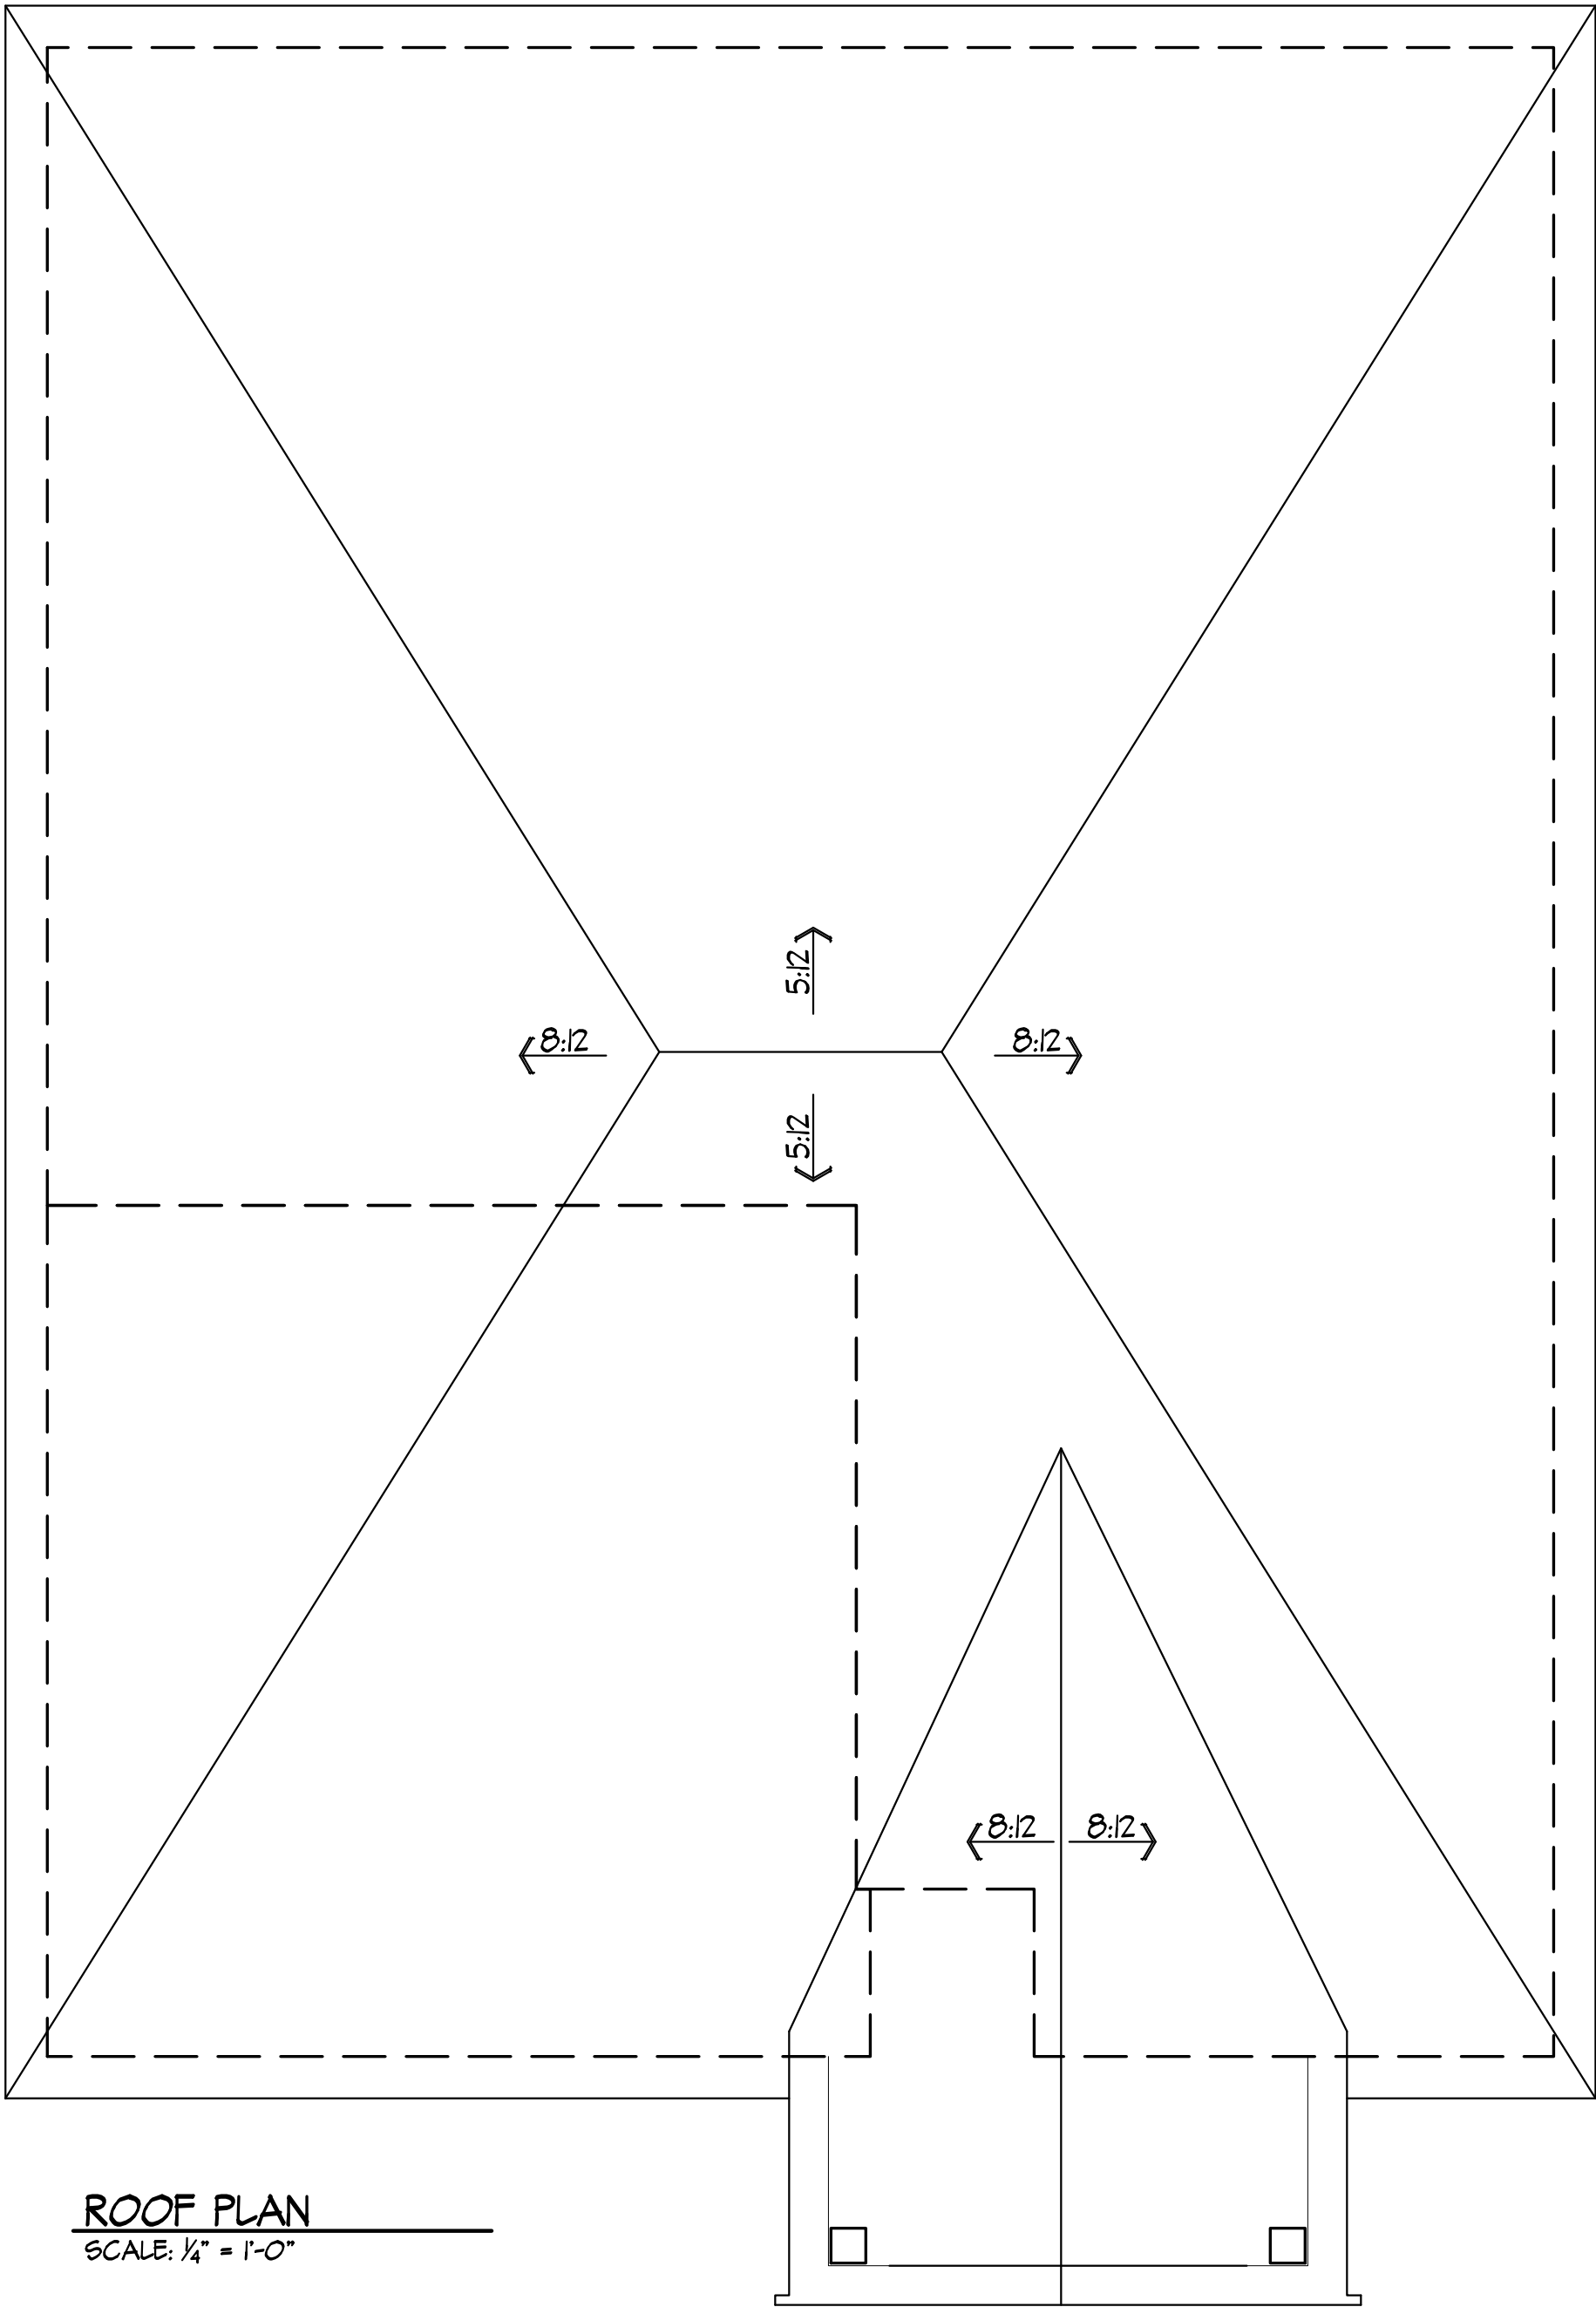

DATE:	December 11, 2024
LAST SAVED BY:	Kayleigh.Edge
LAST SAVED:	Wed, 11 Dec 2024 - 11:16am
CREATED:	Wed, 29 Aug 2012 - 9:56am
FILE NAME:	LEONARDO 121124.dwg
TIME PLOTTED:	Wed, 11 Dec 2024 - 11:39am
REVISION:	
PDR#A.B.	DATE:08/15/13
PDR#298	DATE:10/14/13
PDR#730	DATE:7/11/18
PDR#832	DATE:01/07/19
PDR#000	DATE:00/00/00

CUSTOMER NAME RESIDENCE	
STREET	
CITY	
LOT #	
LEONARDO	
ROOF PLAN C ELEV.	

Sheet Number
C.9.1.1